
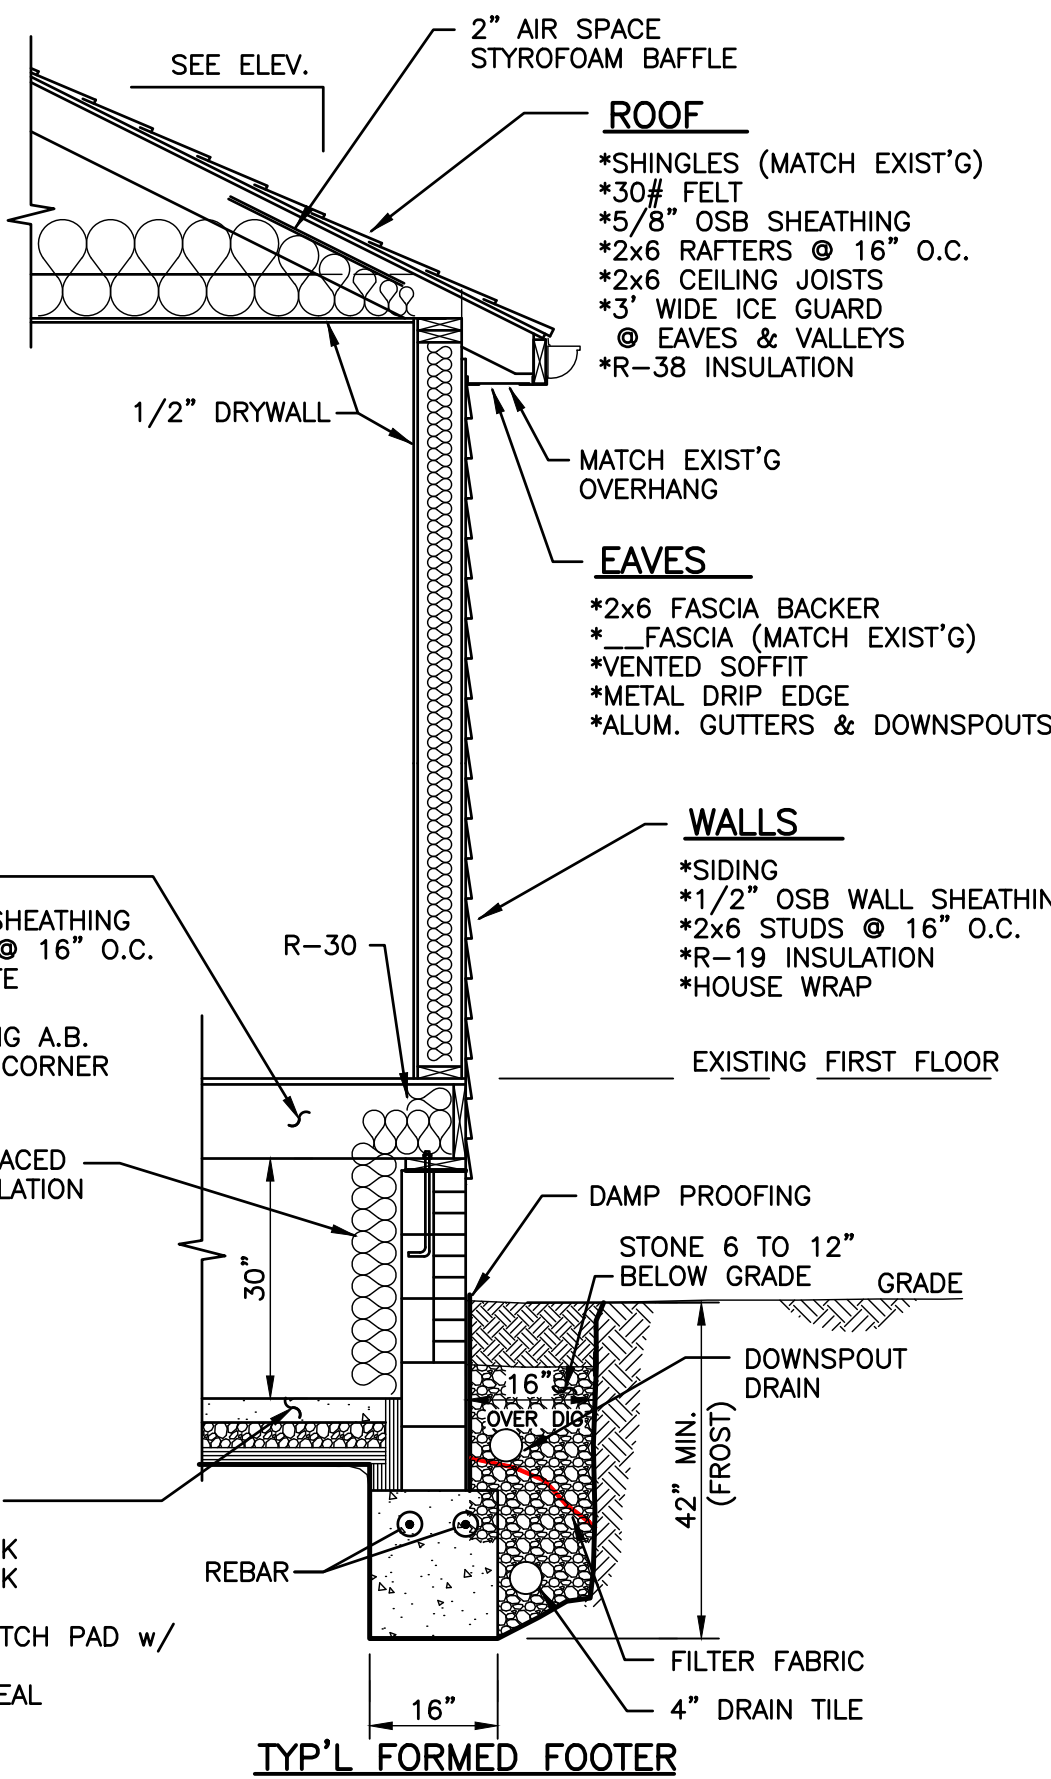


CHARNIGO RESIDENCE ADDITION

357 Kensington Road
Rocky River, OHIO


DRAWING INDEX:

- T-1 TITLE SHEET
- SITE PLAN
- TYPICAL SECTION
- D-1 DEMO 1ST FLOOR PLAN
- D-2 DEMO 2ND FLOOR PLAN
- D-3 DEMO RIGHT & REAR ELEVATIONS
- A-1 PROPOSED 1ST FLOOR PLAN
- A-2 PROPOSED 2ND FLOOR PLAN
- A-3 PROPOSED RIGHT & REAR ELEVATIONS
- A-4 PROPOSED FOUNDATION PLAN
- PROPOSED ROOF PLAN

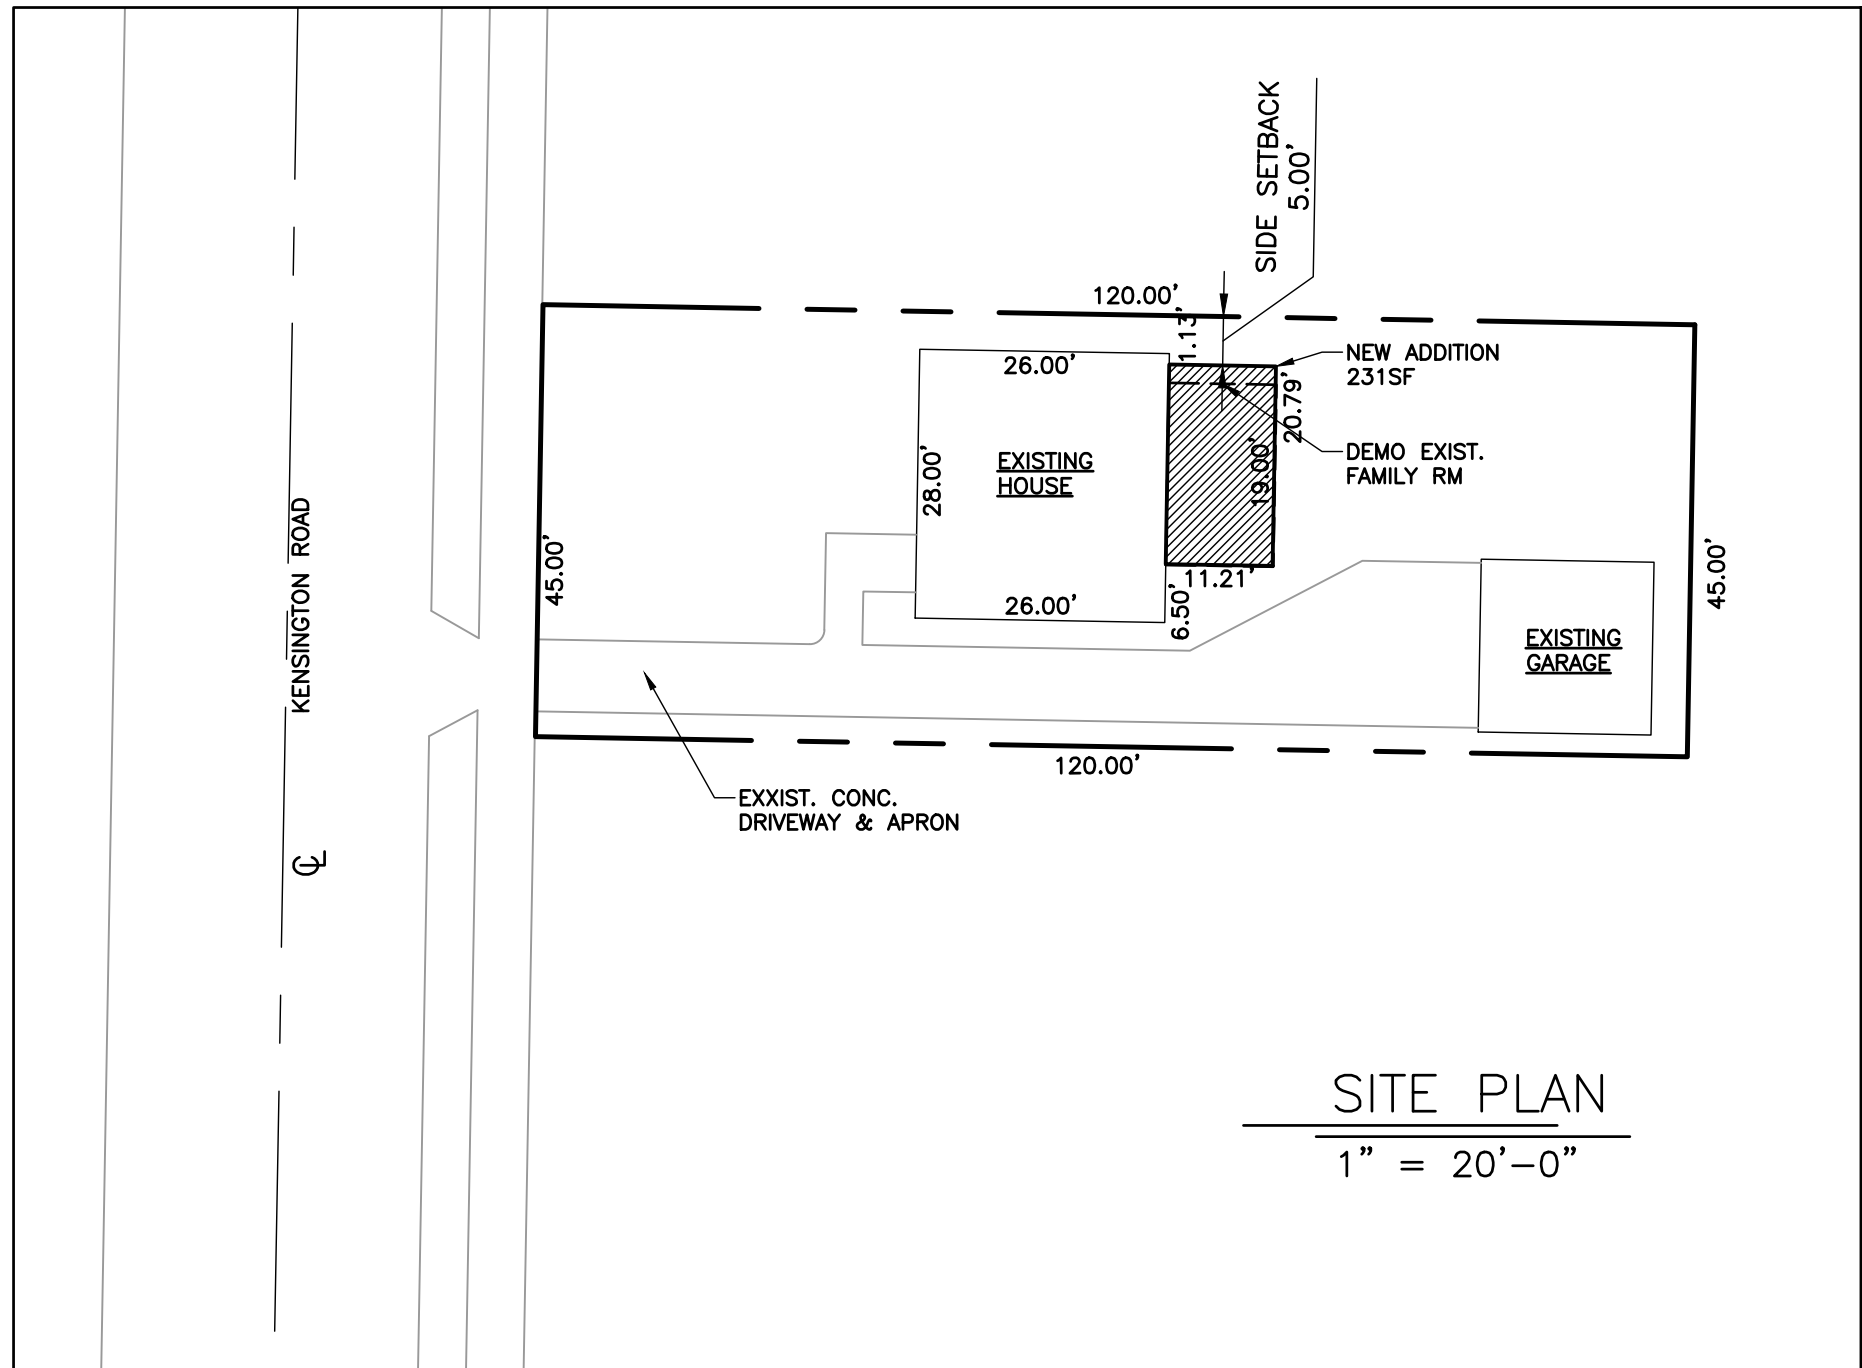

THESE DRAWINGS AND DESIGNS WILL BE RELEASED AT AUTHORIZATION OF PROJECT. ANY USAGE WITHOUT WRITTEN CONSENT WILL DEFER ANY AND ALL RESPONSIBILITIES OF DOVER HOME REMODELERS, INC. ALL RIGHTS ARE HEREBY SPECIFICALLY RESERVED.

DATE	REVISIONS
01/06/2021	CITY ARB
29341 Lorain Road North Olmsted, Ohio 44070 Phone: 440-777-7555 Fax: 440-777-8188 www.doverremodeling.com	
DOVER SINCE 1984 Home Remodelers, Inc.	
NAME: CHARNIGO, BRENT & KATHLEEN	PRELIMINARY APPROVAL DATE
ADDRESS: 357 KENSINGTON RD.	CUSTOMER SIGNATURE
CITY: ROCKY RIVER, OH	FINAL APPROVAL DATE
ZIP CODE: 44116	CUSTOMER SIGNATURE
PHONE:	
Date:	01/05/2021
Scale:	AS NOTED
Drawn By:	CA
Sales Rep:	SB
Drawing:	T-1

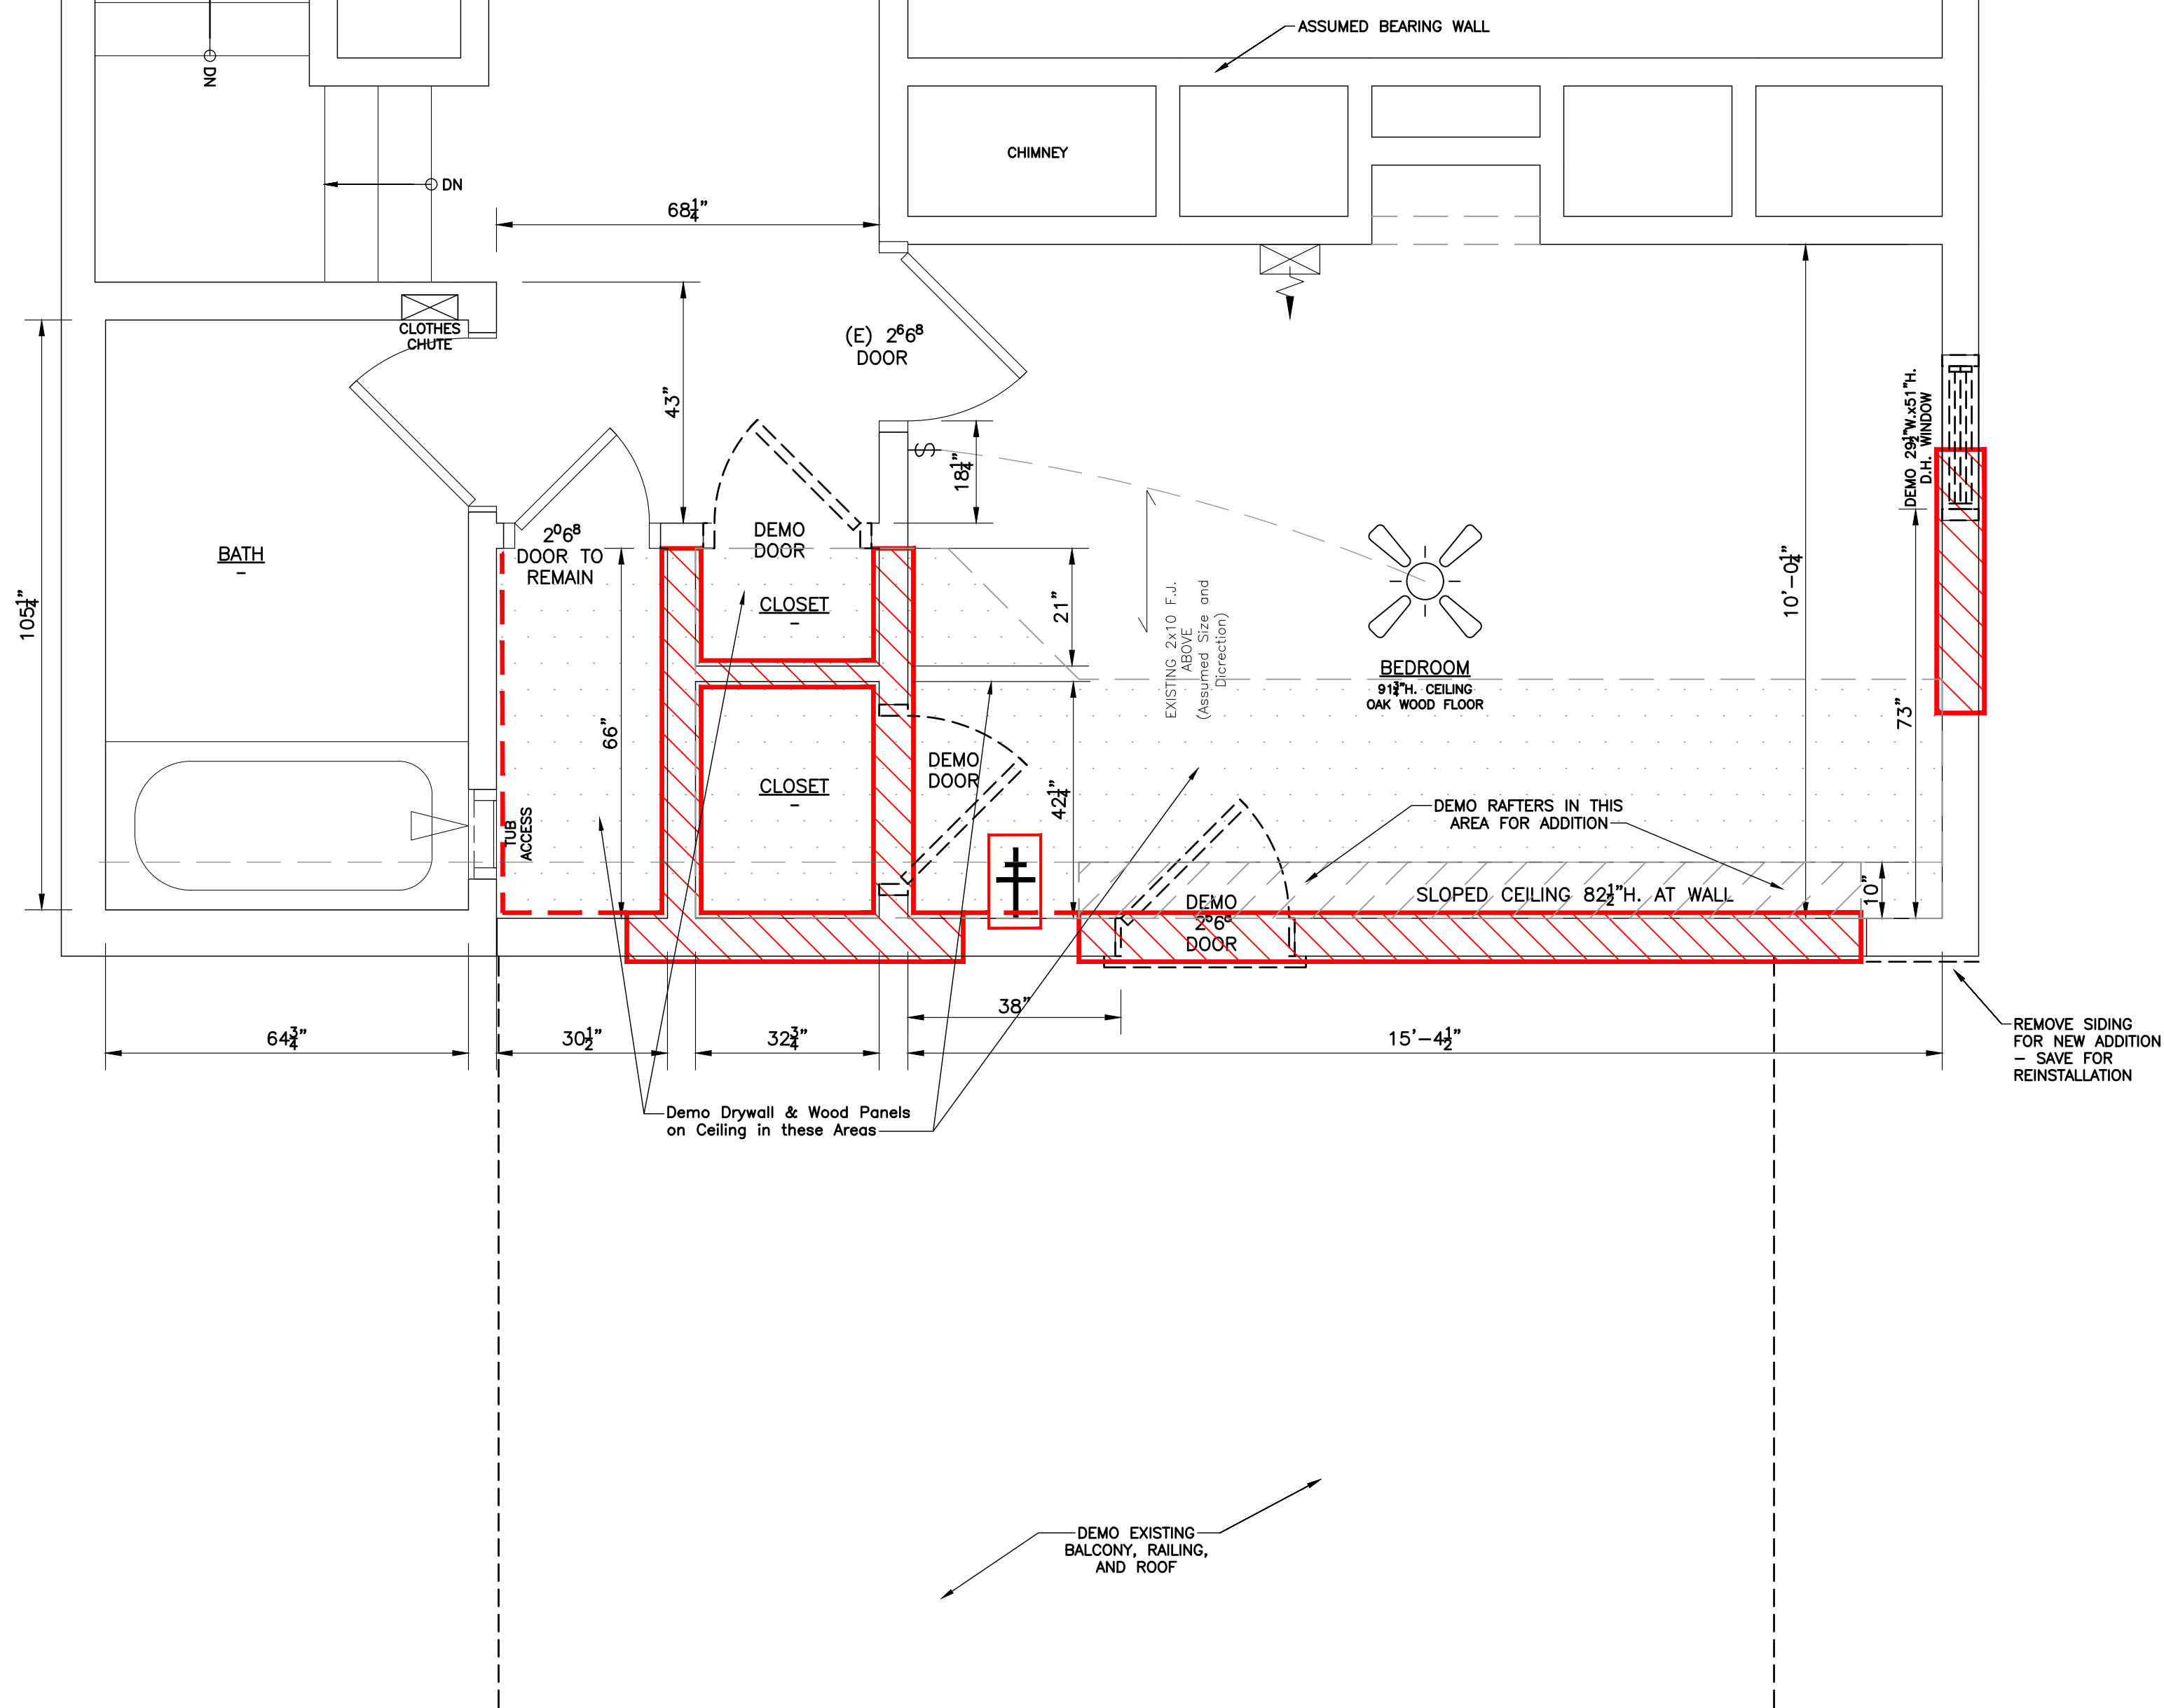

EXISTING 2ND FLOOR PLAN
Scale: 1/2" = 1'-0"

MECHANICAL-ELECTRICAL LEGEND			
\$	- SINGLE POLE SWITCH	⊕	- 110 RECEPTACLE
\$3	- 3-WAY POLE SWITCH	⊕3	- 110 QUAD RECEPTACLE
\$4	- 4-WAY POLE SWITCH	⊕	- 110 RECEPTACLE (SWITCHED OUTLET)
\$D	- SINGLE POLE SWITCH w/ DIMMER	⊕G	- 110 GFI RECEPTACLE
\$3D	- 3-WAY POLE SWITCH w/ DIMMER	⊕G WP	- 110 GFI RECEPTACLE WEATHER PROTECTED
⊙	- INCANDESCENT LIGHT	⊕	- 220 RECEPTACLE
⊙	- WALL MOUNTED LIGHT	⊕	- DISPOSAL
⊙	- EXHAUST FAN	⊕	- SMOKE DETECTOR
⊙	- EXHAUST FAN/LIGHT	⊕	- THERMOSTAT
⊙	- RECESSED CAN LIGHT	⊕	- PHONE JACK
⊙	- RECESSED CAN LIGHT EYEBALL LIGHT	⊕	- TV/CABLE JACK
⊙	- PULL CHAIN LIGHT	⊕	- ELECTRICAL PANEL
⊙	- PENDANT LIGHT	⊕	- SUPPLY AIR
⊕	- FLORESCENT LIGHT UNDER WALL CABINET	⊕	- RETURN AIR
⊕	- FLORESCENT LIGHT	⊕	- REPRESENTS REMOVED OPENING
⊕	- CEILING FAN W/ LIGHT	(C)	- DENOTES CHANGE DEVICE
		(D)	- DENOTES DEMO DEVICE
		(E)	- DENOTES EXISTING

THESE DRAWINGS AND DESIGNS WILL BE RELEASED AT AUTHORIZATION OF PROJECT. ANY USAGE WITHOUT WRITTEN CONSENT WILL DEFER ANY AND ALL RESPONSIBILITIES OF DOVER HOME REMODELERS, INC. ALL RIGHTS ARE HEREBY SPECIFICALLY RESERVED.

29341 Lorain Road
North Olmsted, Ohio 44070
Phone: 440-777-7555
Fax: 440-777-8188
www.doverremodeling.com

SINCE 1984

DOVER

 

Home Remodelers, Inc.

NAME: CHARNIGO, BRENT & KATHLEEN
ADDRESS: 357 KENSINGTON RD.
CITY: ROCKY RIVER, OH
ZIP CODE: 44116
PHONE:


PRELIMINARY APPROVAL DATE: _____
CUSTOMER SIGNATURE: _____
FINAL APPROVAL DATE: _____
CUSTOMER SIGNATURE: _____

DATE: 10/09/2020
SCALE: 1/2"=1'-0"
DRAWN BY: BT/CA
SALES REP: SB
DRAWING: D-2

REVISIONS
01/06/2021 CITY ARB

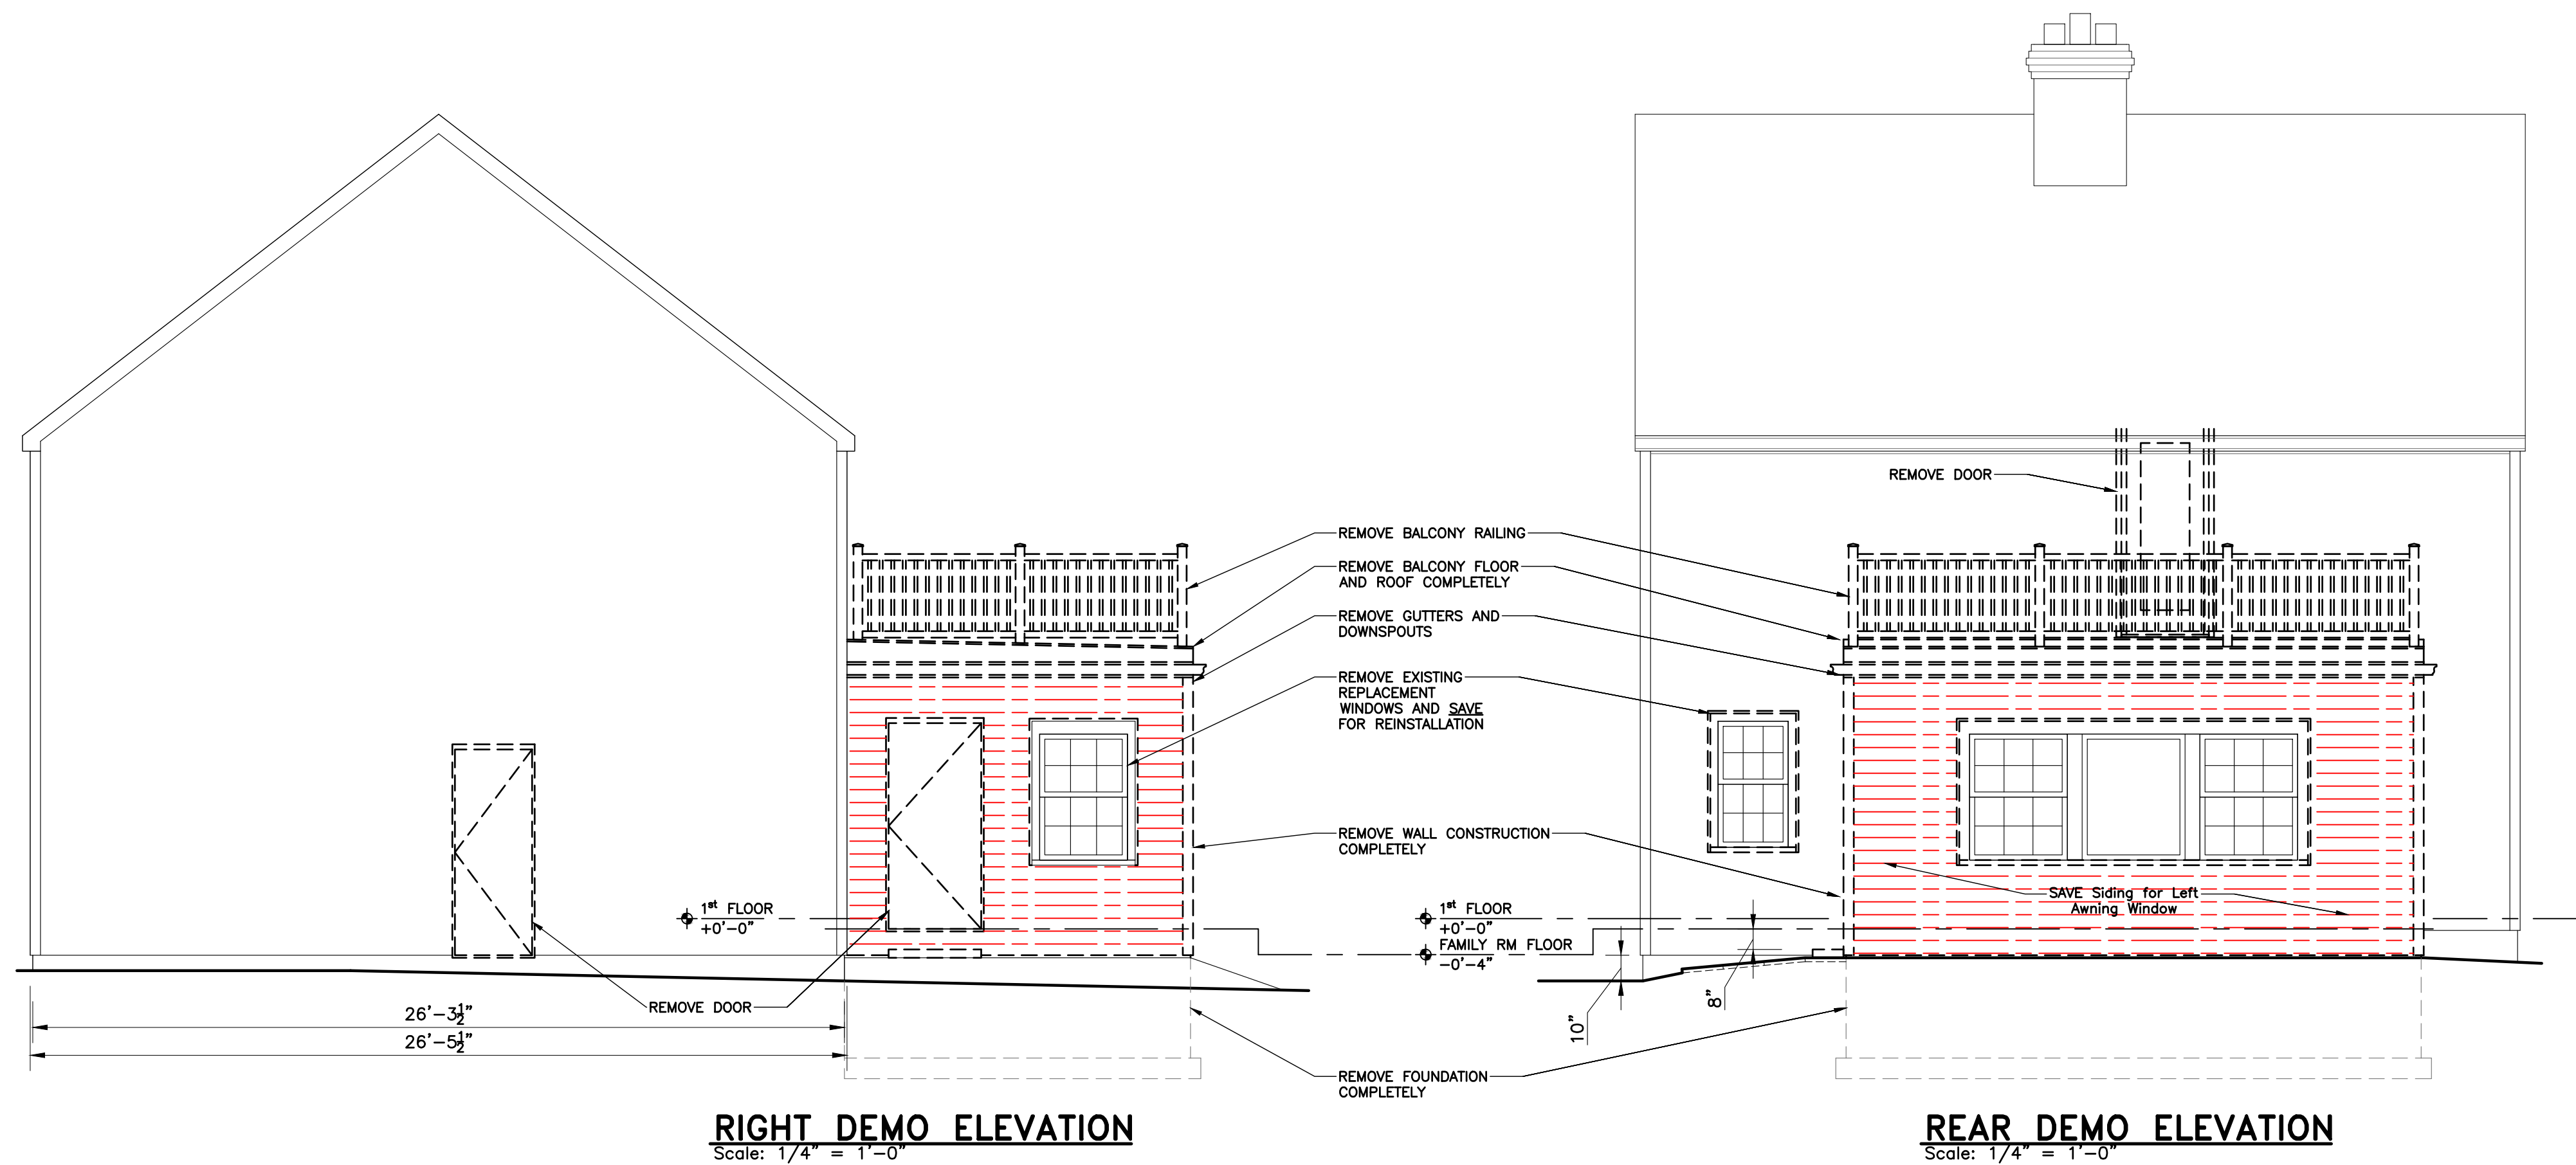

NAME: CHARNIGO, BRENT & KATHLEEN ADDRESS: 357 KENSINGTON RD. CITY: ROCKY RIVER, OH ZIP CODE: 44116 PHONE:		PRELIMINARY APPROVAL DATE _____ CUSTOMER SIGNATURE _____ FINAL APPROVAL DATE _____ CUSTOMER SIGNATURE _____		29341 Lorain Road North Olmsted, Ohio 44070 Phone: 440-777-7555 Fax: 440-777-8188 www.doverremodeling.com		DATE 01/06/2021		REVISIONS CITY ARB	
SINCE 1984 D OVER Home Remodelers, Inc.									

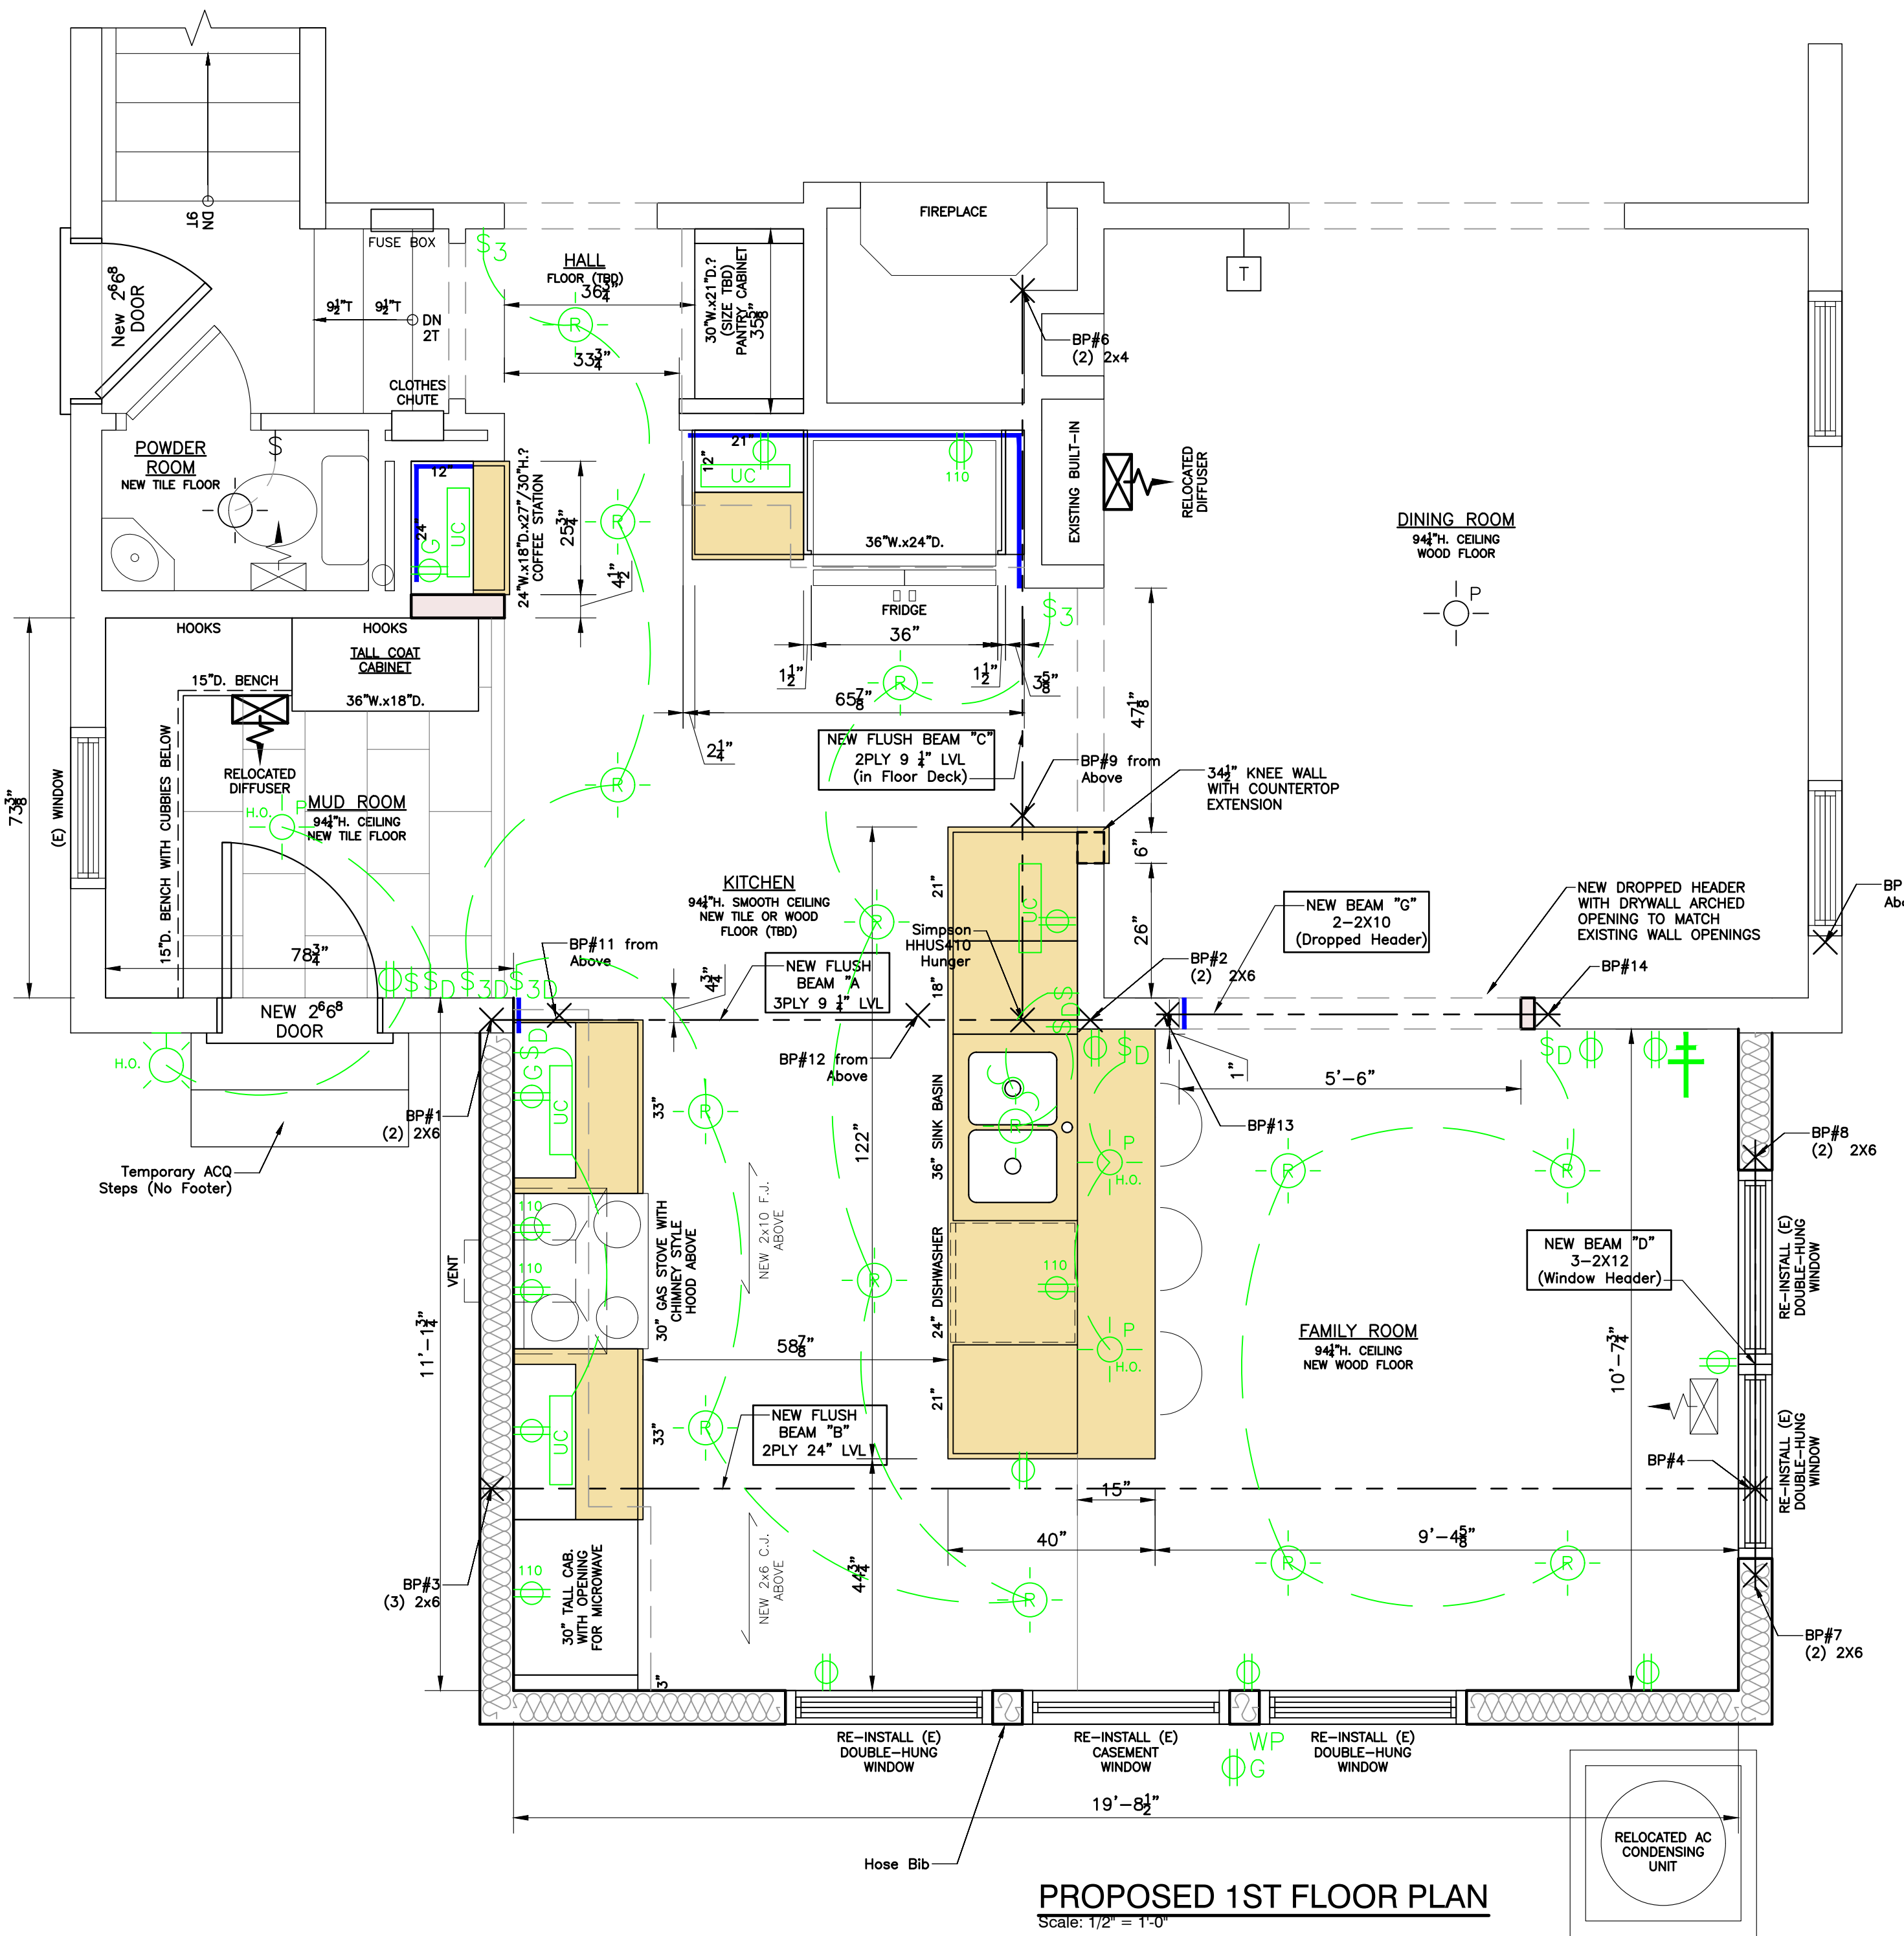

PROPOSED 1ST FLOOR PLAN
Scale: 1/2" = 1'-0"

GENERAL CONSTRUCTION NOTES:

- EXISTING WALL TO REMAIN
- NEW WALL, 2x4 WD STUDS @ 16" OC. WITH 1/2" DRYWALL EACH SIDE.
- NEW DRYWALL/FLOOR SHEETING WHERE SHOWN ON DRAWING IN BLUE

MECHANICAL-ELECTRICAL LEGEND

\$ - SINGLE POLE SWITCH	⊕ - 110 RECEPTACLE
\$3 - 3-WAY POLE SWITCH	⊕ - 110 QUAD RECEPTACLE
\$4 - 4-WAY POLE SWITCH	⊕ - 110 RECEPTACLE (SWITCHED OUTLET)
\$D - SINGLE POLE SWITCH w/ DIMMER	⊕ - 110 GFI RECEPTACLE
\$3D - 3-WAY POLE SWITCH w/ DIMMER	⊕WP - 110 GFI RECEPTACLE WEATHER PROTECTED
⊙ - INCANDESCENT LIGHT	⊕ - 220 RECEPTACLE
⊙ - WALL MOUNTED LIGHT	⊕ - DISPOSAL
⊙ - EXHAUST FAN	⊕ - SMOKE DETECTOR
⊙ - EXHAUST FAN/LIGHT	⊕ - THERMOSTAT
⊙ - RECESSED CAN LIGHT	⊕ - PHONE JACK
⊙ - RECESSED CAN LIGHT EYEBALL LIGHT	⊕ - TV/CABLE JACK
⊙ - PULL CHAIN LIGHT	⊕ - ELECTRICAL PANEL
⊙ - PENDANT LIGHT	⊕ - SUPPLY AIR
⊕ - FLORESCENT LIGHT UNDER WALL CABINET	⊕ - RETURN AIR
⊕ - FLORESCENT LIGHT	⊕ - REPRESENTS REMOVED OPENING
⊕ - CEILING FAN W/ LIGHT	

(C) - DENOTES CHANGE DEVICE
(D) - DENOTES DEMO DEVICE
(E) - DENOTES EXISTING

THESE DRAWINGS AND DESIGNS WILL BE RELEASED AT AUTHORIZATION OF PROJECT. ANY USAGE WITHOUT WRITTEN CONSENT WILL DEFER ANY AND ALL RESPONSIBILITIES OF DOVER HOME REMODELERS, INC. ALL RIGHTS ARE HEREBY SPECIFICALLY RESERVED.

29341 Lorain Road
North Olmsted, Ohio 44070
Phone: 440-777-7555
Fax: 440-777-8188
www.doverremodeling.com

SINCE 1984

DOVER

Home Remodelers, Inc.

NAME: CHARNIGO, BRENT & KATHLEEN

PRELIMINARY APPROVAL DATE: 10/09/2020

ADDRESS: 357 KENSINGTON RD.

CITY: ROCKY RIVER, OH

ZIP CODE: 44116

PHONE:

CUSTOMER SIGNATURE

DATE

DATE

CUSTOMER SIGNATURE


Date: 10/09/2020

Scale: 1/2"=1'-0"

Drawn By: BT/CA

Sales Rep: SB

Drawing: A-1

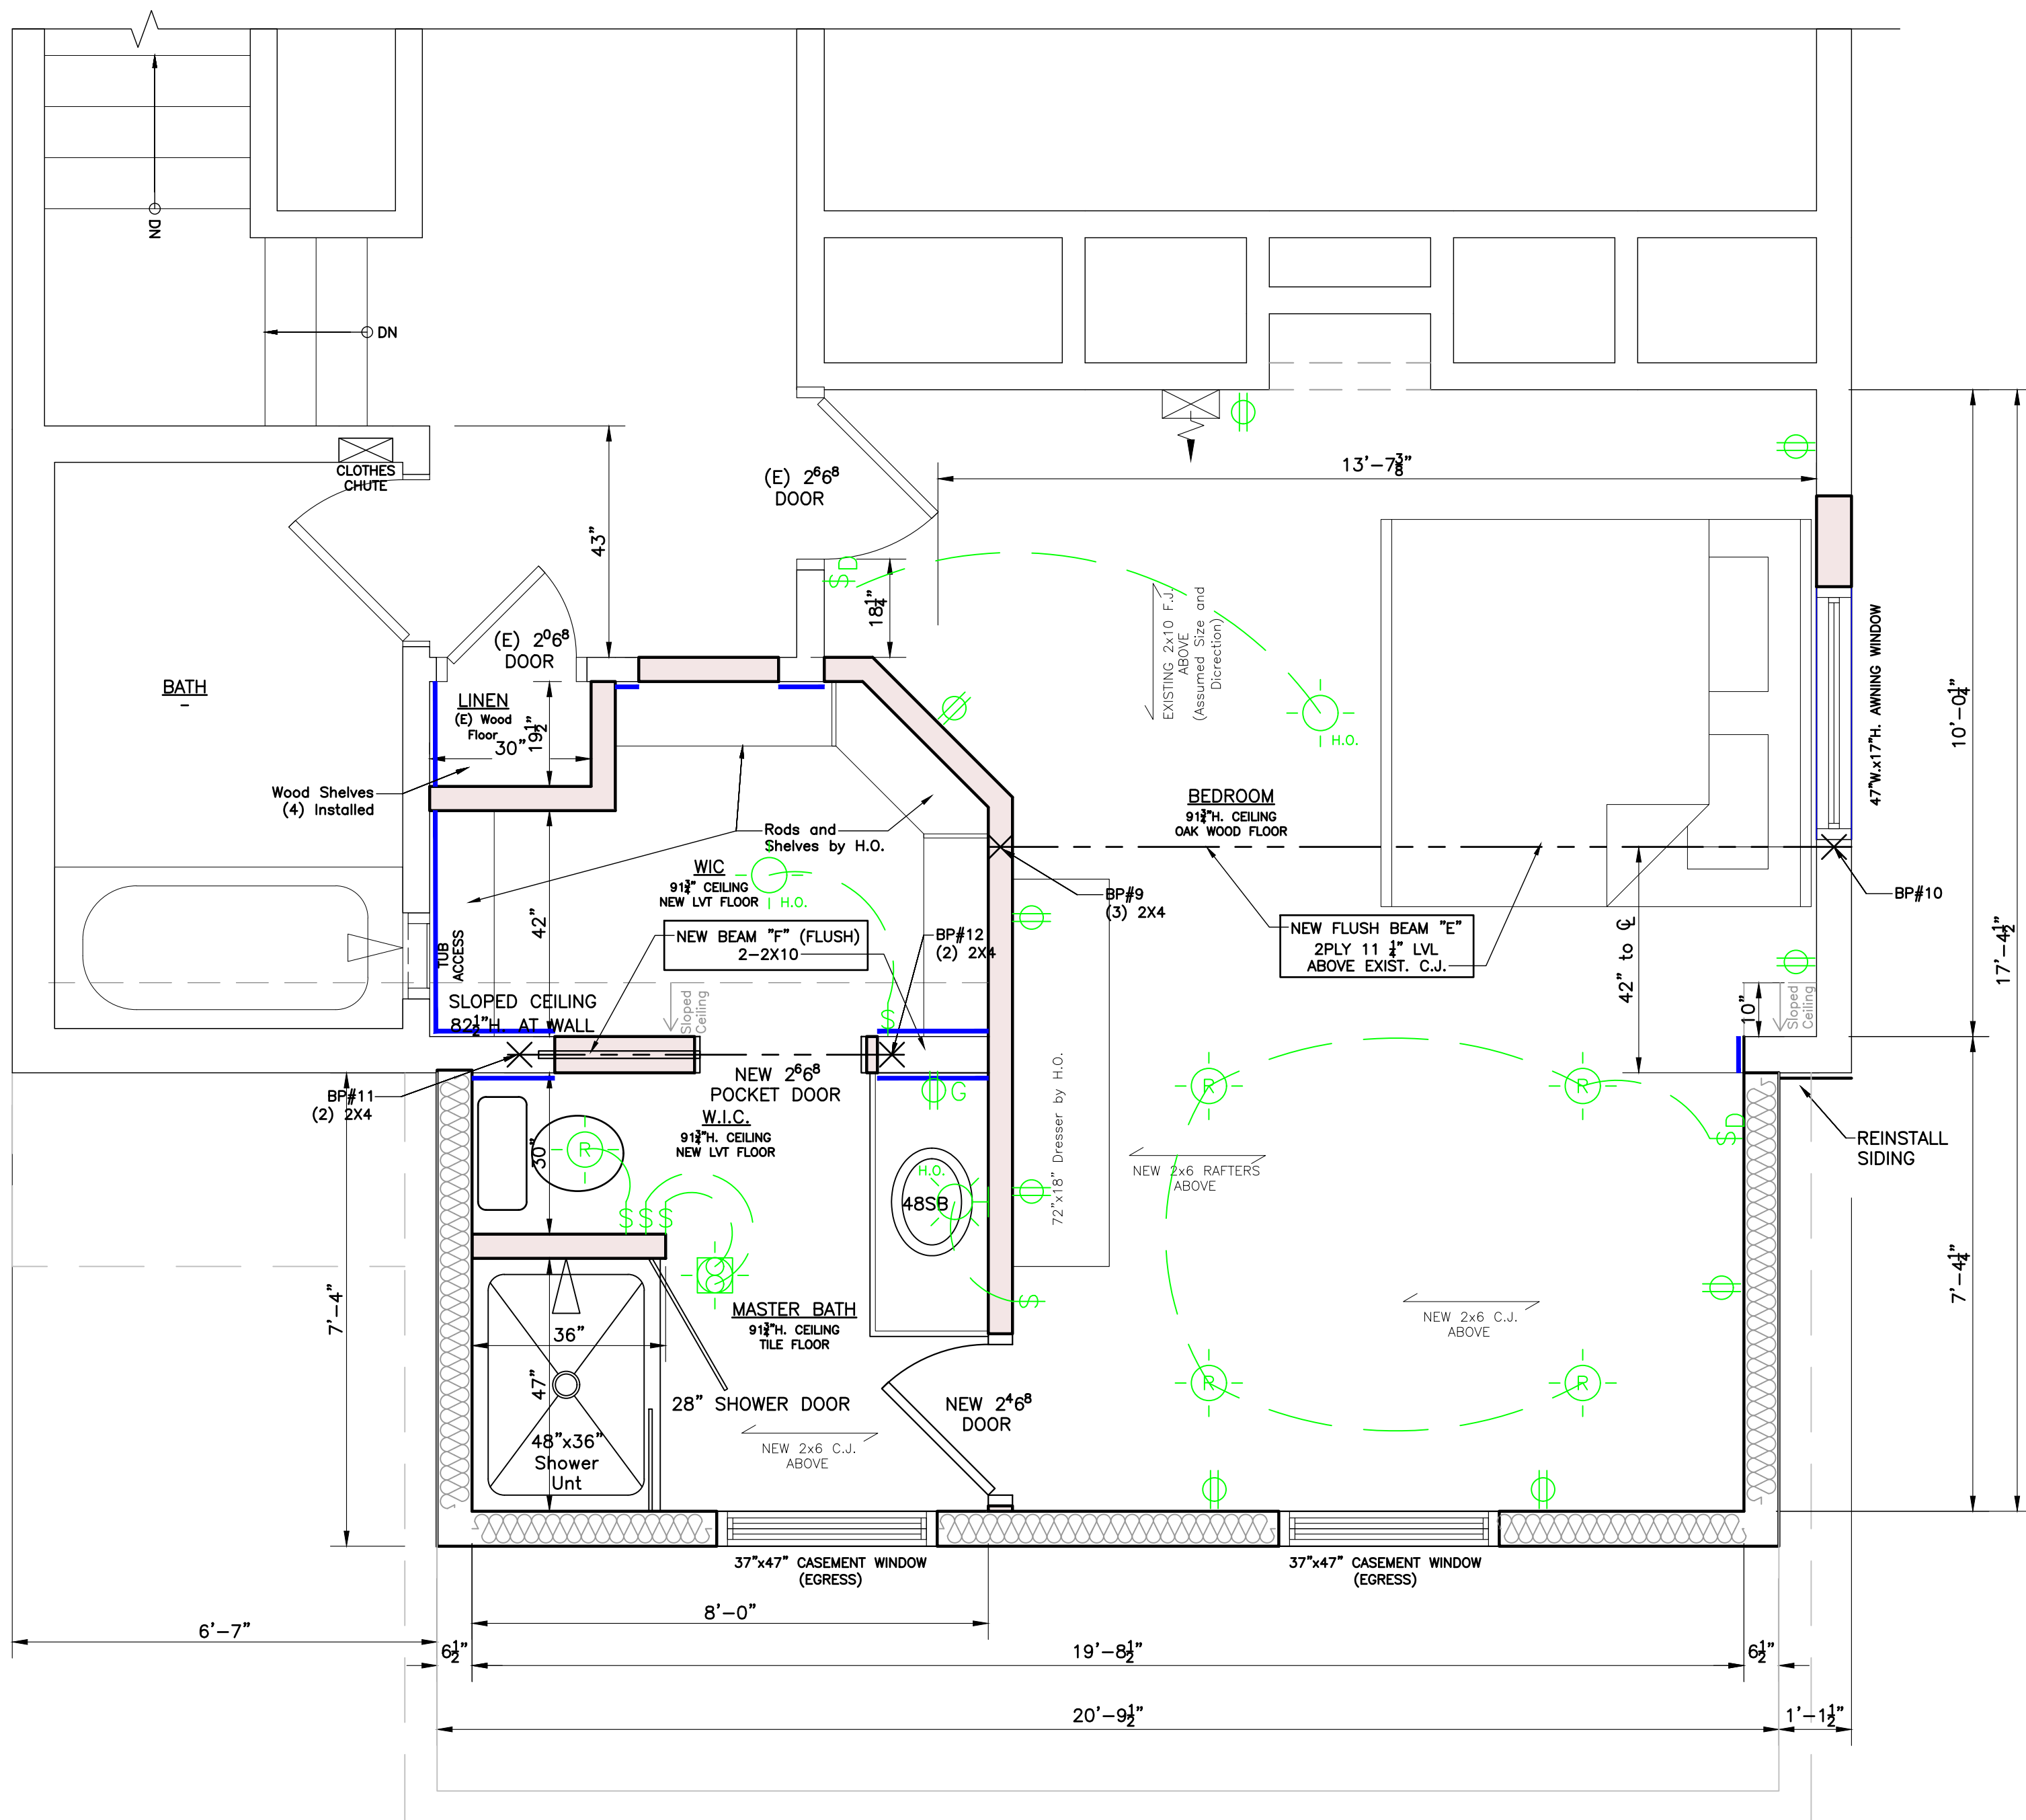

PROPOSED 2ND FLOOR PLAN
Scale: 1/2" = 1'-0"

GENERAL CONSTRUCTION NOTES:

- EXISTING WALL TO REMAIN
- NEW WALL, 2x4 WD STUDS @ 16" OC. WITH 1/2" DRYWALL EACH SIDE.
- NEW DRYWALL/FLOOR SHEETING WHERE SHOWN ON DRAWING IN BLUE

MECHANICAL-ELECTRICAL LEGEND

\$ - SINGLE POLE SWITCH	⊕ - 110 RECEPTACLE
\$3 - 3-WAY POLE SWITCH	⊕ - 110 QUAD RECEPTACLE
\$4 - 4-WAY POLE SWITCH	⊕ - 110 RECEPTACLE (SWITCHED OUTLET)
\$D - SINGLE POLE SWITCH w/ DIMMER	⊕G - 110 GFI RECEPTACLE
\$3D - 3-WAY POLE SWITCH w/ DIMMER	⊕GWP - 110 GFI RECEPTACLE WEATHER PROTECTED
⊙ - INCANDESCENT LIGHT	⊕ - 220 RECEPTACLE
⊙ - WALL MOUNTED LIGHT	⊕ - DISPOSAL
⊕ - EXHAUST FAN	⊕S - SMOKE DETECTOR
⊕ - EXHAUST FAN/LIGHT	⊕T - THERMOSTAT
⊕R - RECESSED CAN LIGHT	⊕ - PHONE JACK
⊕E - RECESSED CAN LIGHT EYEBALL LIGHT	⊕ - TV/CABLE JACK
⊕P - PULL CHAIN LIGHT	⊕EP - ELECTRICAL PANEL
⊕P - PENDANT LIGHT	⊕ - SUPPLY AIR
⊕UC - FLORESCENT LIGHT UNDER WALL CABINET	⊕ - RETURN AIR
⊕FL - FLORESCENT LIGHT	⊕ - REPRESENTS REMOVED OPENING
⊕ - CEILING FAN W/ LIGHT	

(C) - DENOTES CHANGE DEVICE
(D) - DENOTES DEMO DEVICE
(E) - DENOTES EXISTING


THESE DRAWINGS AND DESIGNS WILL BE RELEASED AT AUTHORIZATION OF PROJECT. ANY USAGE WITHOUT WRITTEN CONSENT WILL DEFER ANY AND ALL RESPONSIBILITIES OF DOVER HOME REMODELERS, INC. ALL RIGHTS ARE HEREBY SPECIFICALLY RESERVED.

DATE	REVISIONS
01/06/2021	CITY ARB
29341 Lorain Road North Olmsted, Ohio 44070 Phone: 440-777-7555 Fax: 440-777-8188 www.doverremodeling.com	




NAME: CHARNIGO, BRENT & KATHLEEN	PRELIMINARY APPROVAL DATE
ADDRESS: 357 KENSINGTON RD.	CUSTOMER SIGNATURE
CITY: ROCKY RIVER, OH	FINAL APPROVAL DATE
ZIP CODE: 44116	CUSTOMER SIGNATURE
PHONE:	

Date:	10/09/2020
Scale:	1/2"=1'-0"
Drawn By:	BT/CA
Sales Rep:	SB
Drawing:	A-2

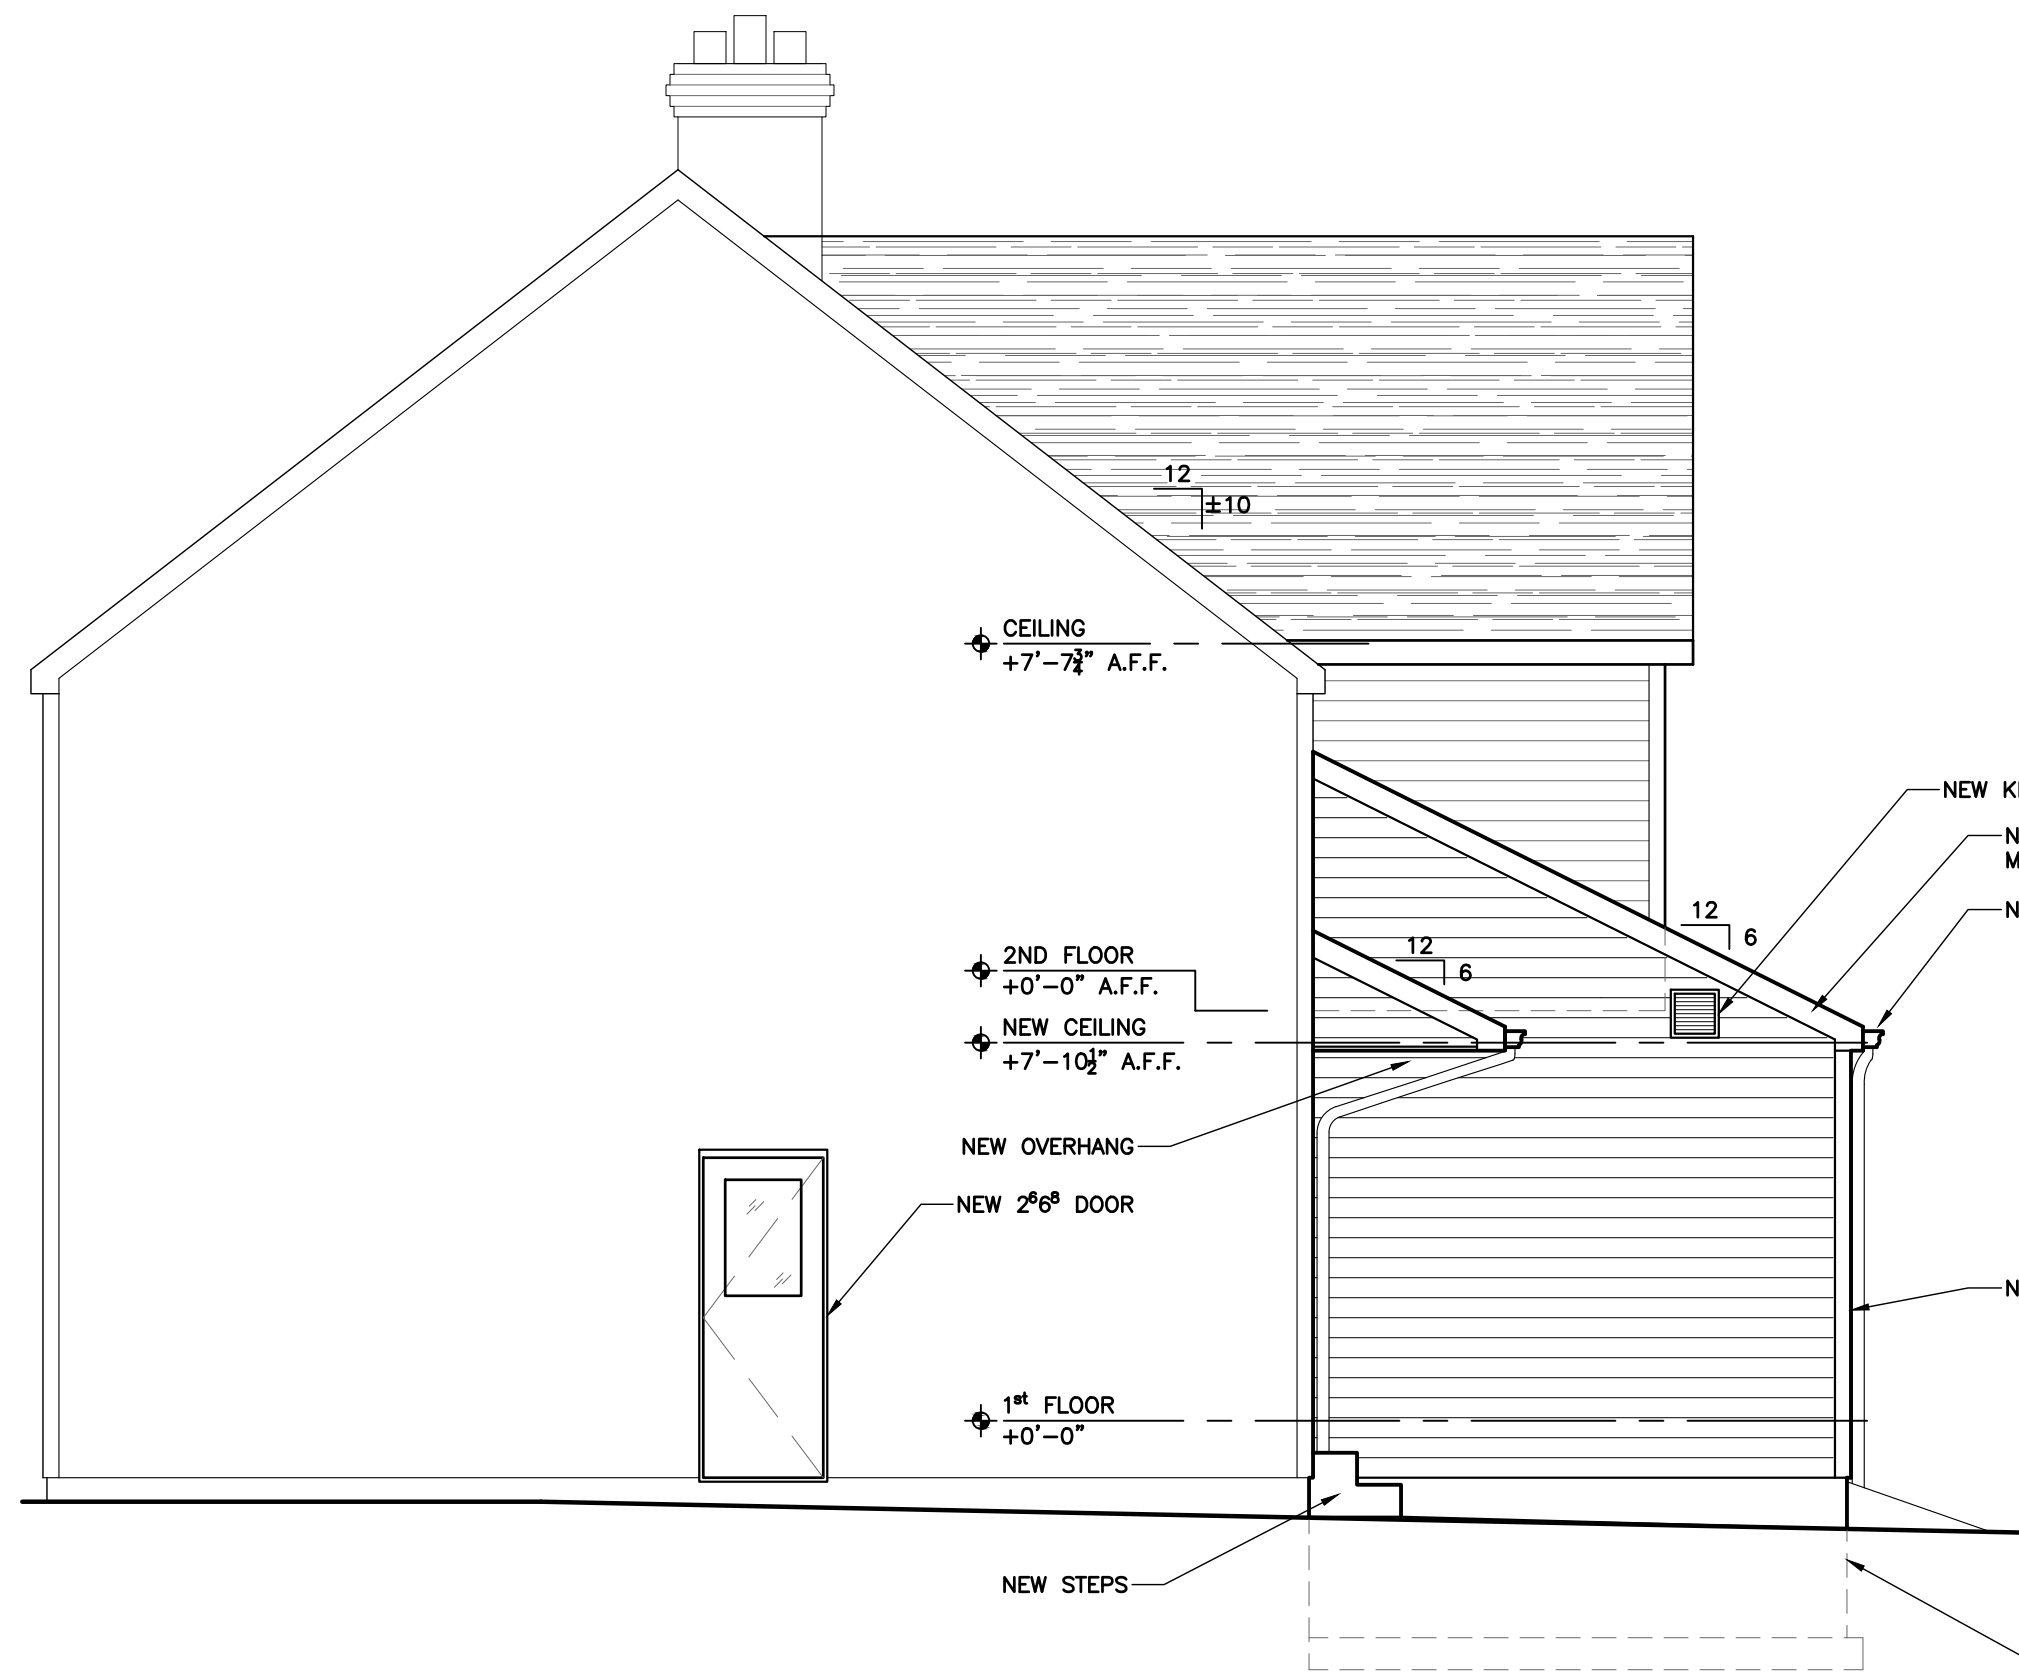

PROPOSED RIGHT ELEVATION
Scale: 1/4" = 1'-0"

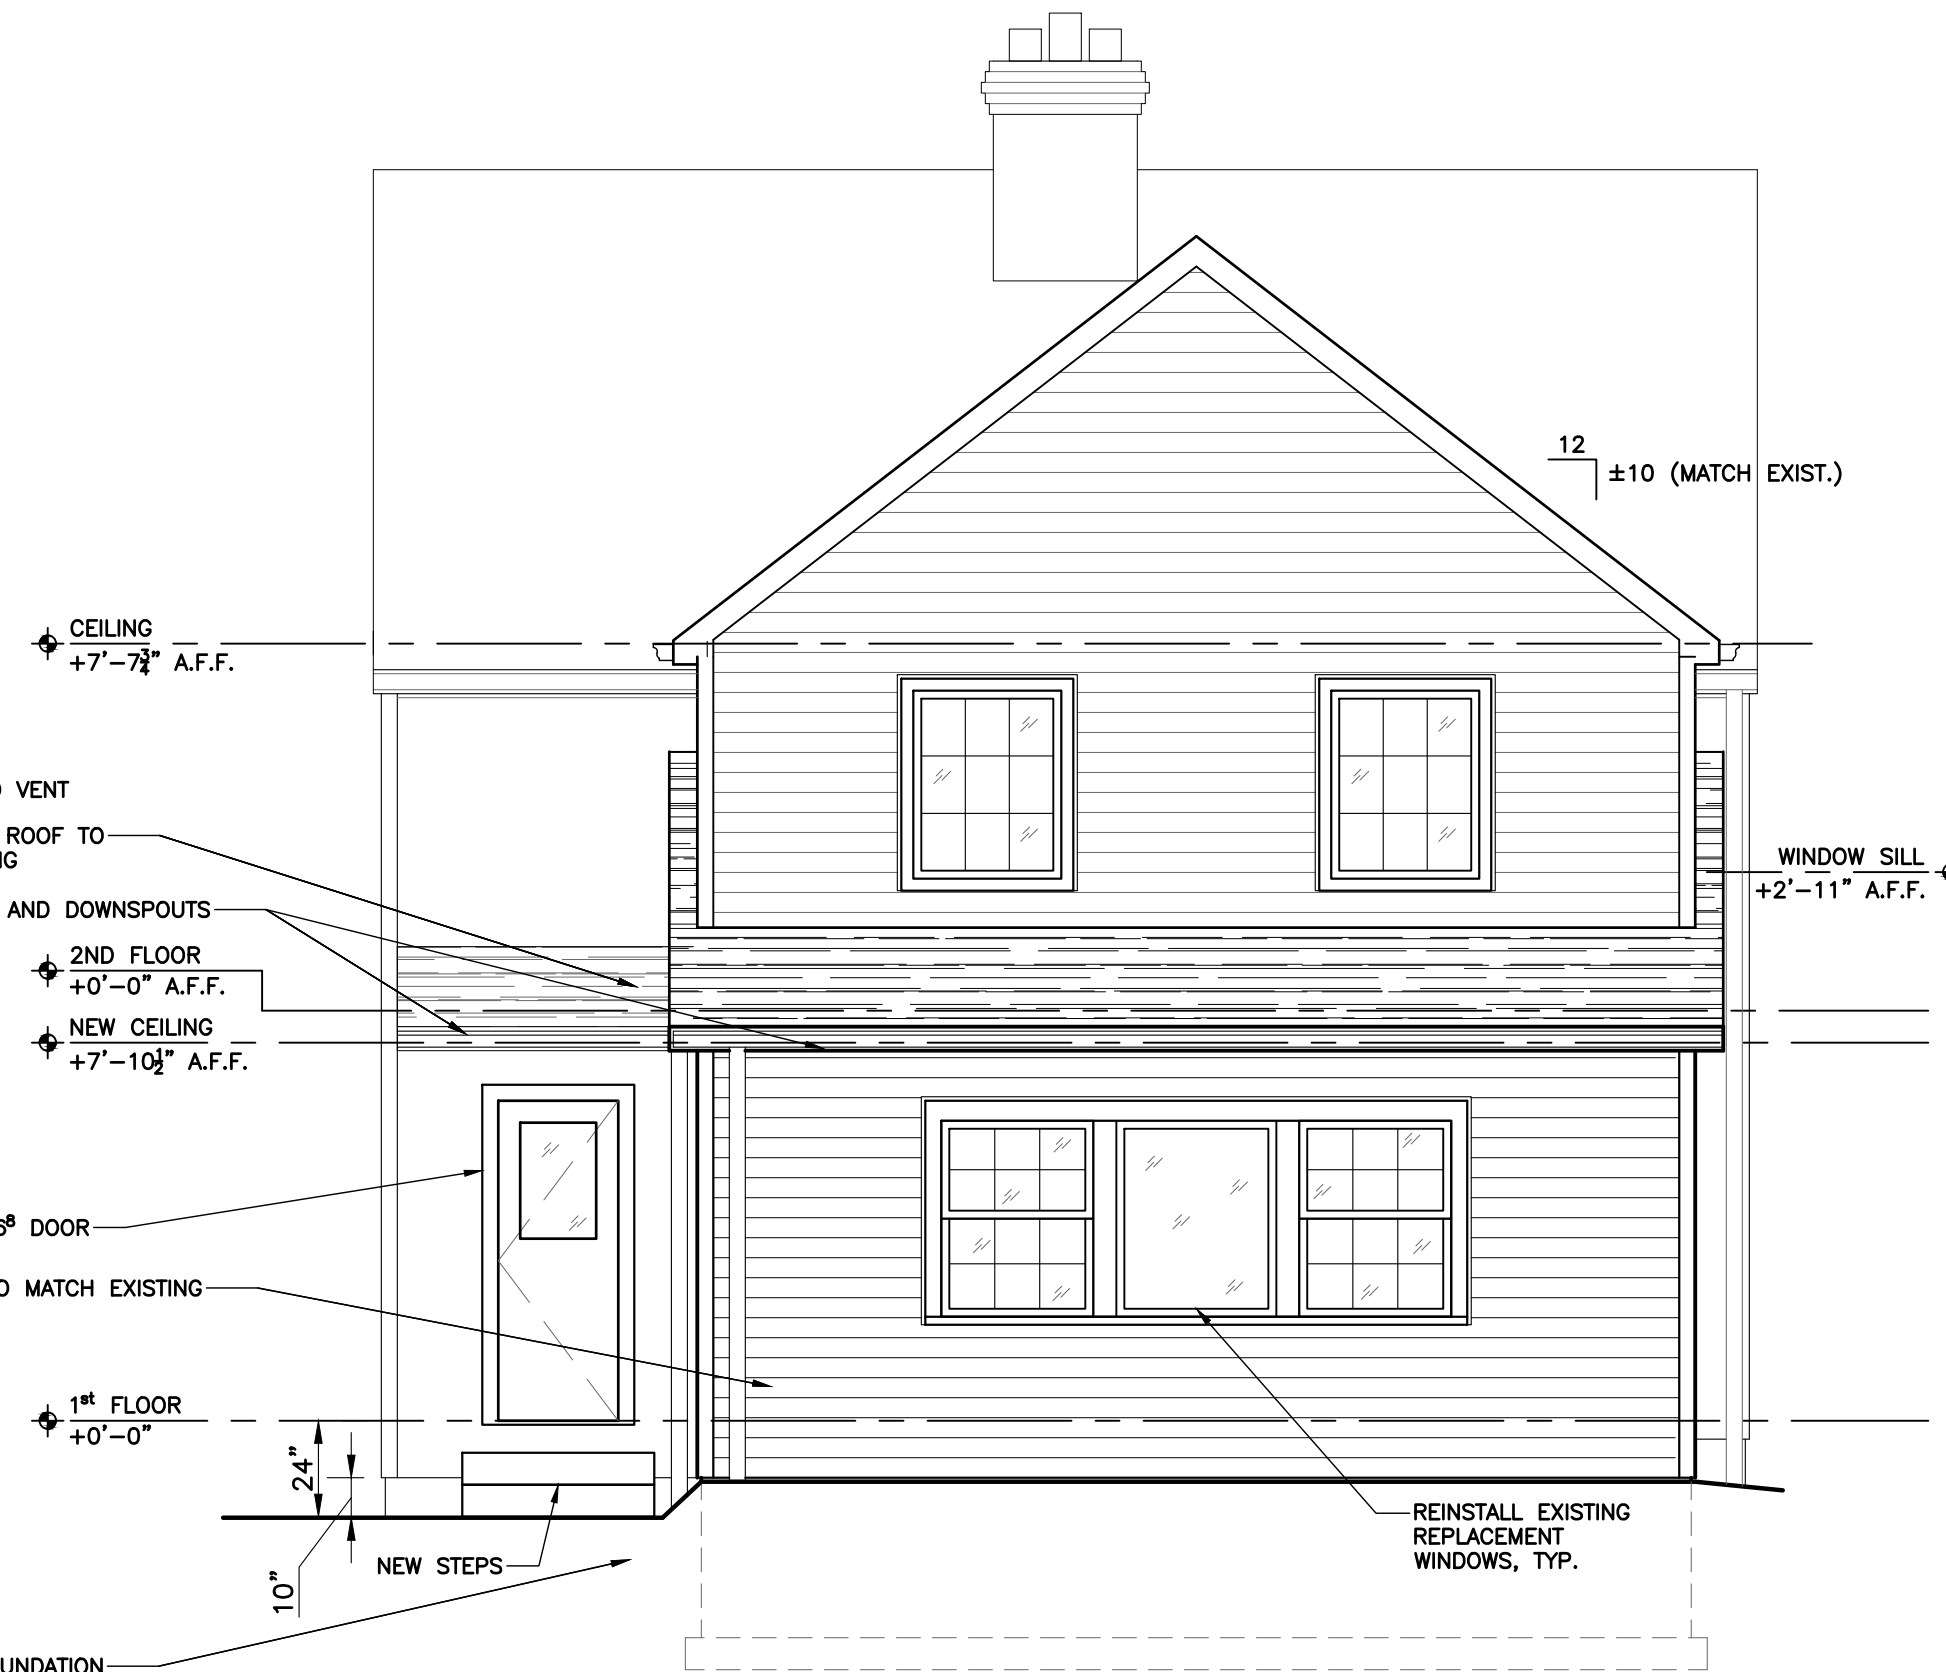

PROPOSED REAR ELEVATION
Scale: 1/4" = 1'-0"

THESE DRAWINGS AND DESIGNS WILL BE RELEASED AT AUTHORIZATION OF PROJECT. ANY USAGE WITHOUT WRITTEN CONSENT WILL DEFER ANY AND ALL RESPONSIBILITIES OF DOVER HOME REMODELERS, INC. ALL RIGHTS ARE HEREBY SPECIFICALLY RESERVED.





29341 Lorain Road
North Olmsted, Ohio 44070
Phone: 440-777-7555
Fax: 440-777-8188
www.doverremodeling.com

DATE	REVISIONS
01/06/2021	CITY ARB

NAME: CHARNIGO, BRENT & KATHLEEN
ADDRESS: 357 KENSINGTON RD.
CITY: ROCKY RIVER, OH
ZIP CODE: 44116
PHONE: _____
PRELIMINARY APPROVAL DATE: _____
CUSTOMER SIGNATURE: _____
FINAL APPROVAL DATE: _____
CUSTOMER SIGNATURE: _____

Date: 10/09/2020
Scale: 1/4"=1'-0"
Drawn By: BT/CA
Sales Rep: SB
Drawing: A-3

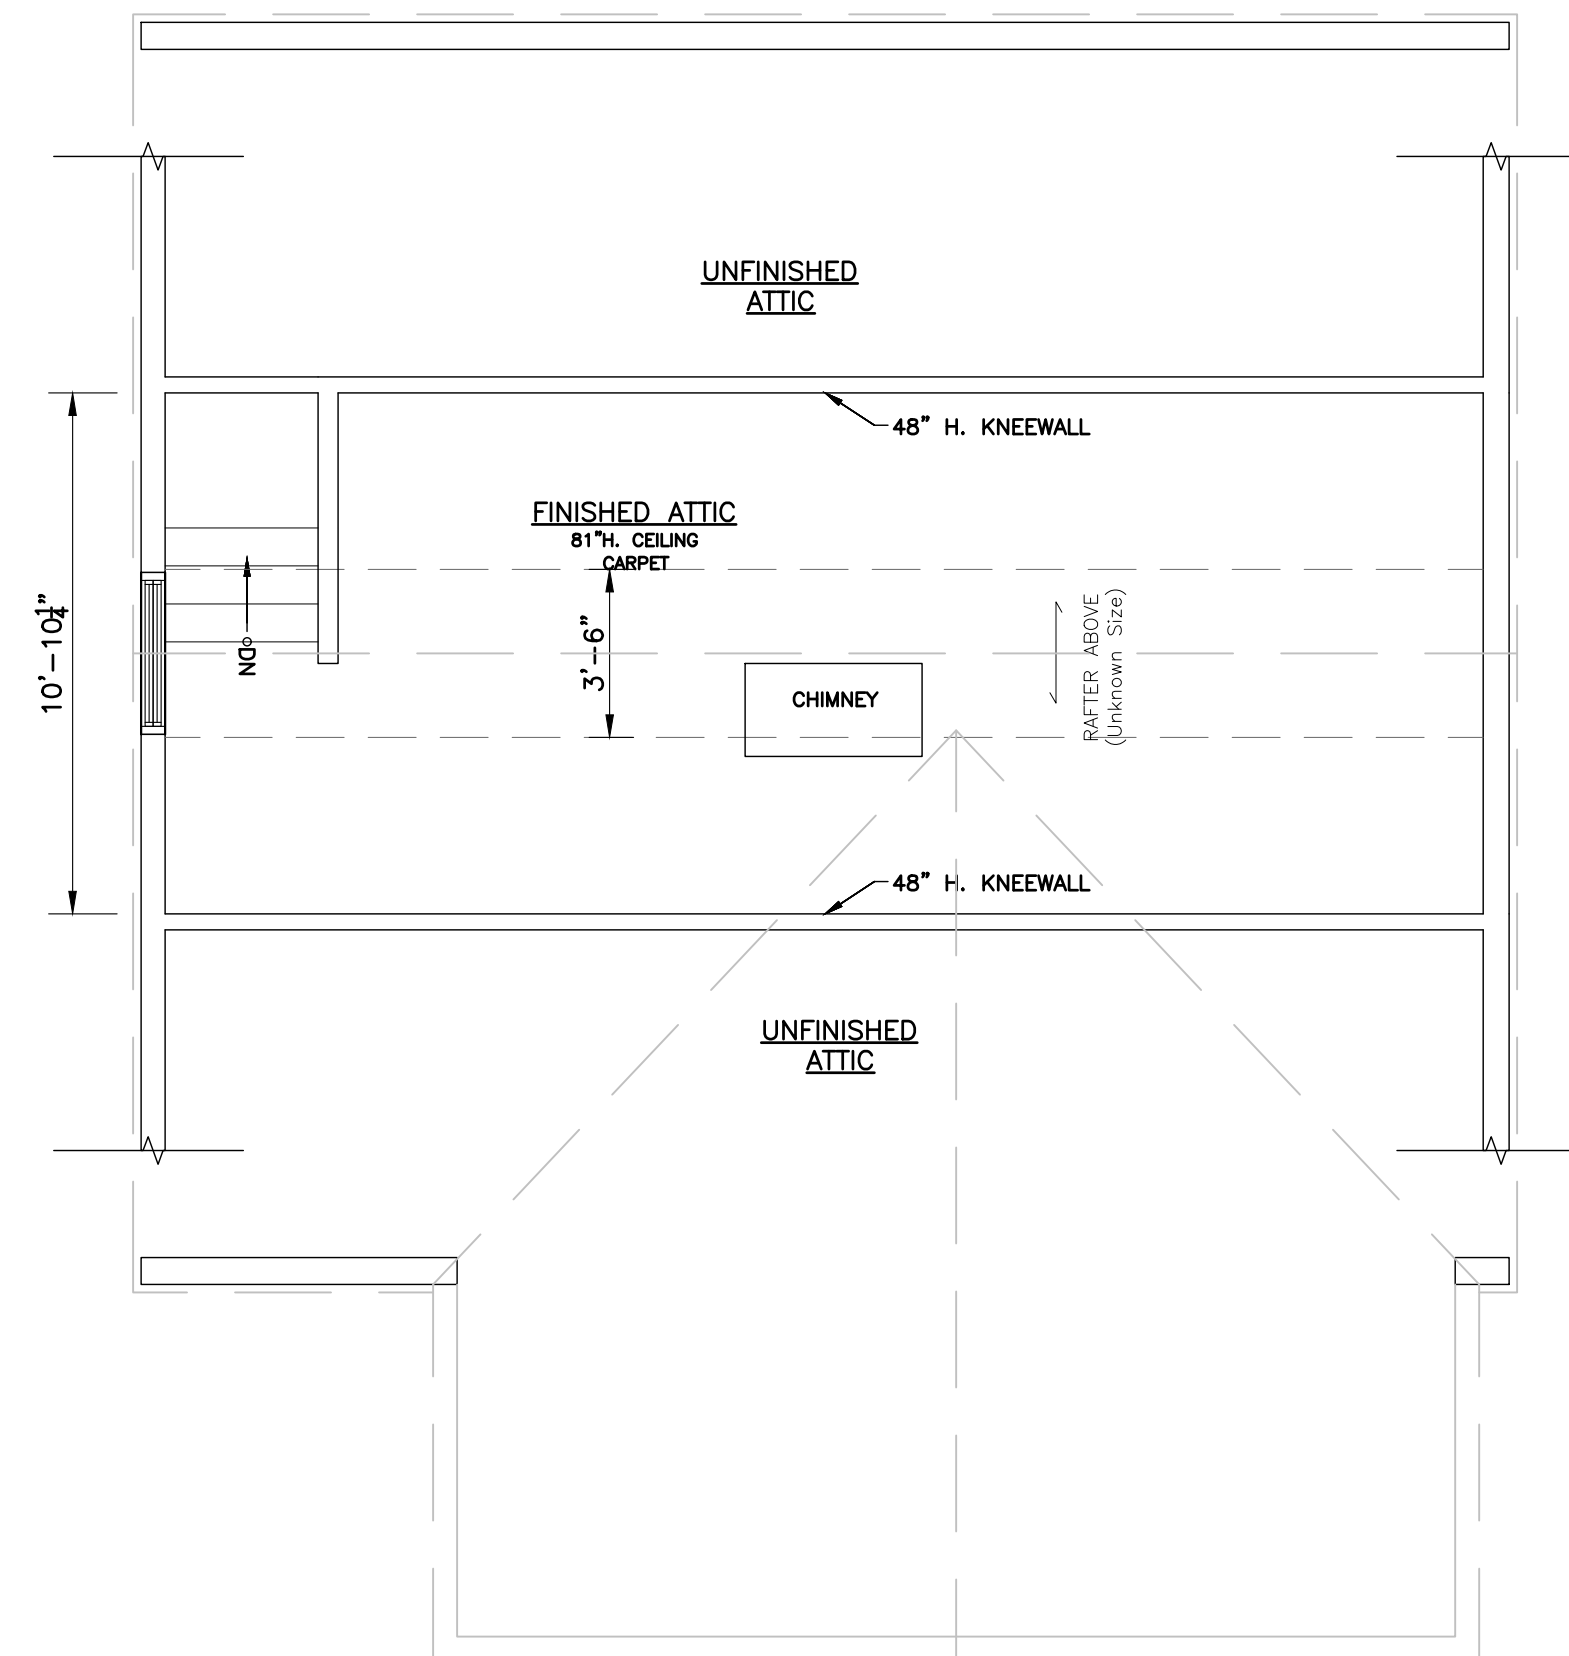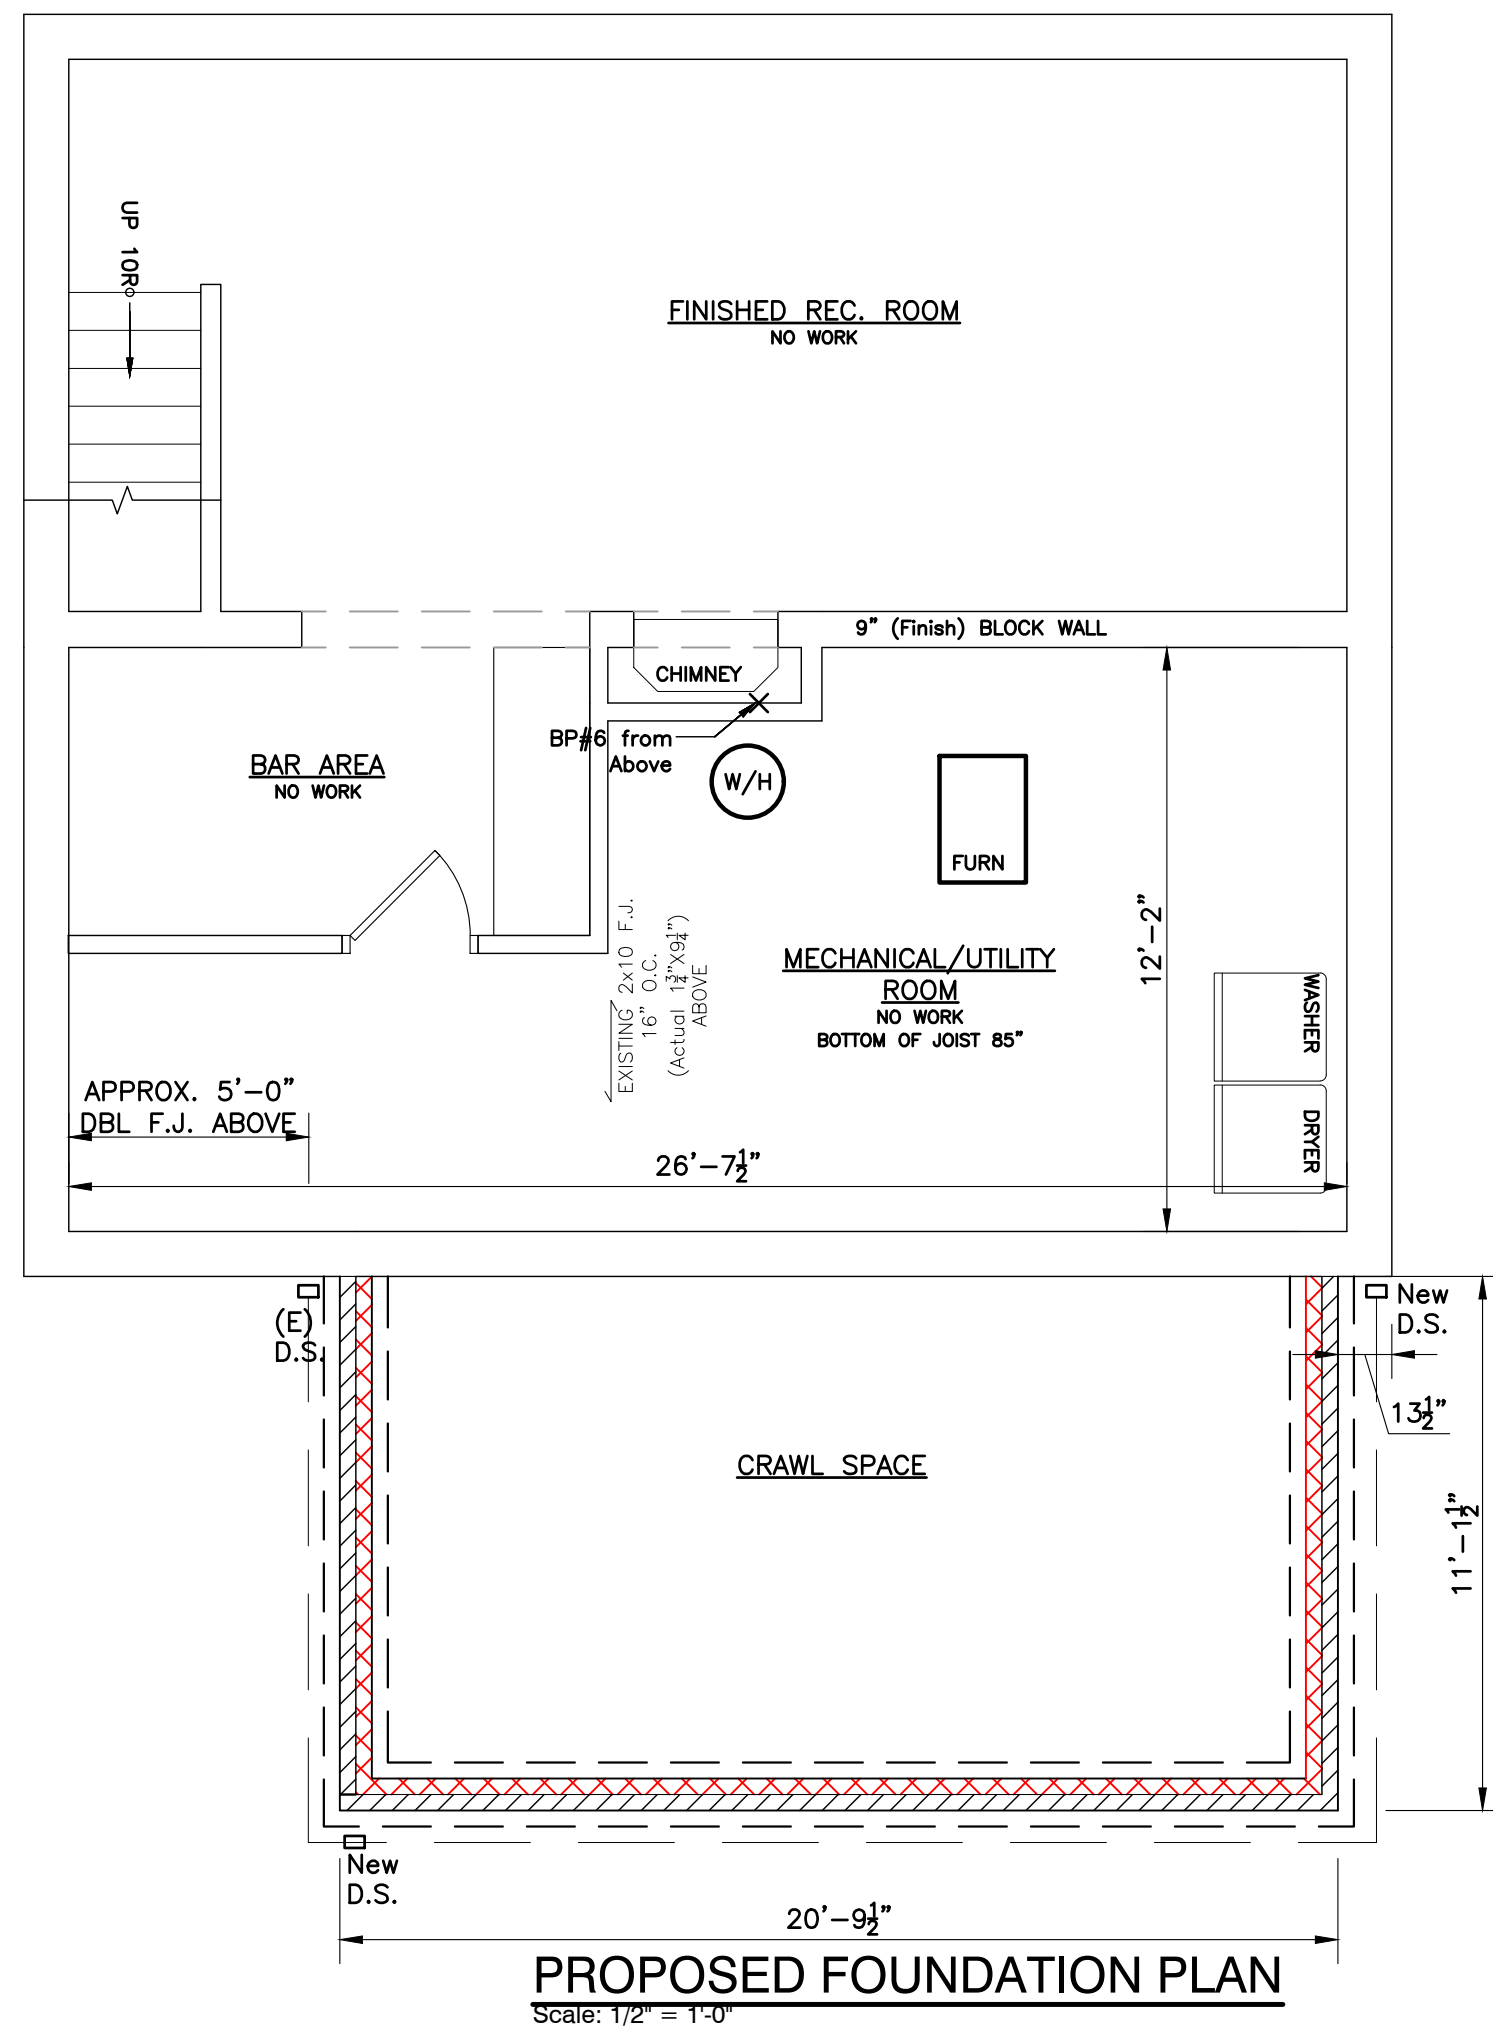

PROPOSED ROOF PLAN

THESE DRAWINGS AND DESIGNS WILL BE
RELEASED AT AUTHORIZATION OF PROJECT.
ANY USAGE WITHOUT WRITTEN CONSENT WILL
DEFER ANY AND ALL RESPONSIBILITIES OF
DOVER HOME REMODELERS, INC. ALL RIGHTS
ARE HEREBY SPECIFICALLY RESERVED.

NAME: CHARNIGO, BRENT & KATHLEEN ADDRESS: 357 KENSINGTON RD. CITY: ROCKY RIVER, OH ZIP CODE: 44116 PHONE:		PRELIMINARY APPROVAL DATE _____ CUSTOMER SIGNATURE _____ FINAL APPROVAL DATE _____ CUSTOMER SIGNATURE _____		DATE 10/09/2020 Scale: 1/4" = 1' - 0" Drawn By: BT/CA Sales Rep: SB Drawing: A-4		DATE 01/06/2021 REVISIONS CITY ARB	
---	--	--	--	---	--	---	--