



- PROPOSED ME PLAN**  
 SCALE: 1/4"=1'-0"
- CEILING FAN
  - LED 5" DIA. RECESSED CATHEDRAL OLG FIXTURE; INSULATED RATED
  - ELECTRICAL RECEPTACLE W/ USB PORT
  - LED OUTDOOR WALL MOUNTED LIGHT FIXTURE; WET RATED
  - ELECTRICAL SWITCH; MATCH EXISTING TYPE AND COLOR
  - ELECTRICAL DIMMER SWITCH; MATCH EXISTING TYPE AND COLOR

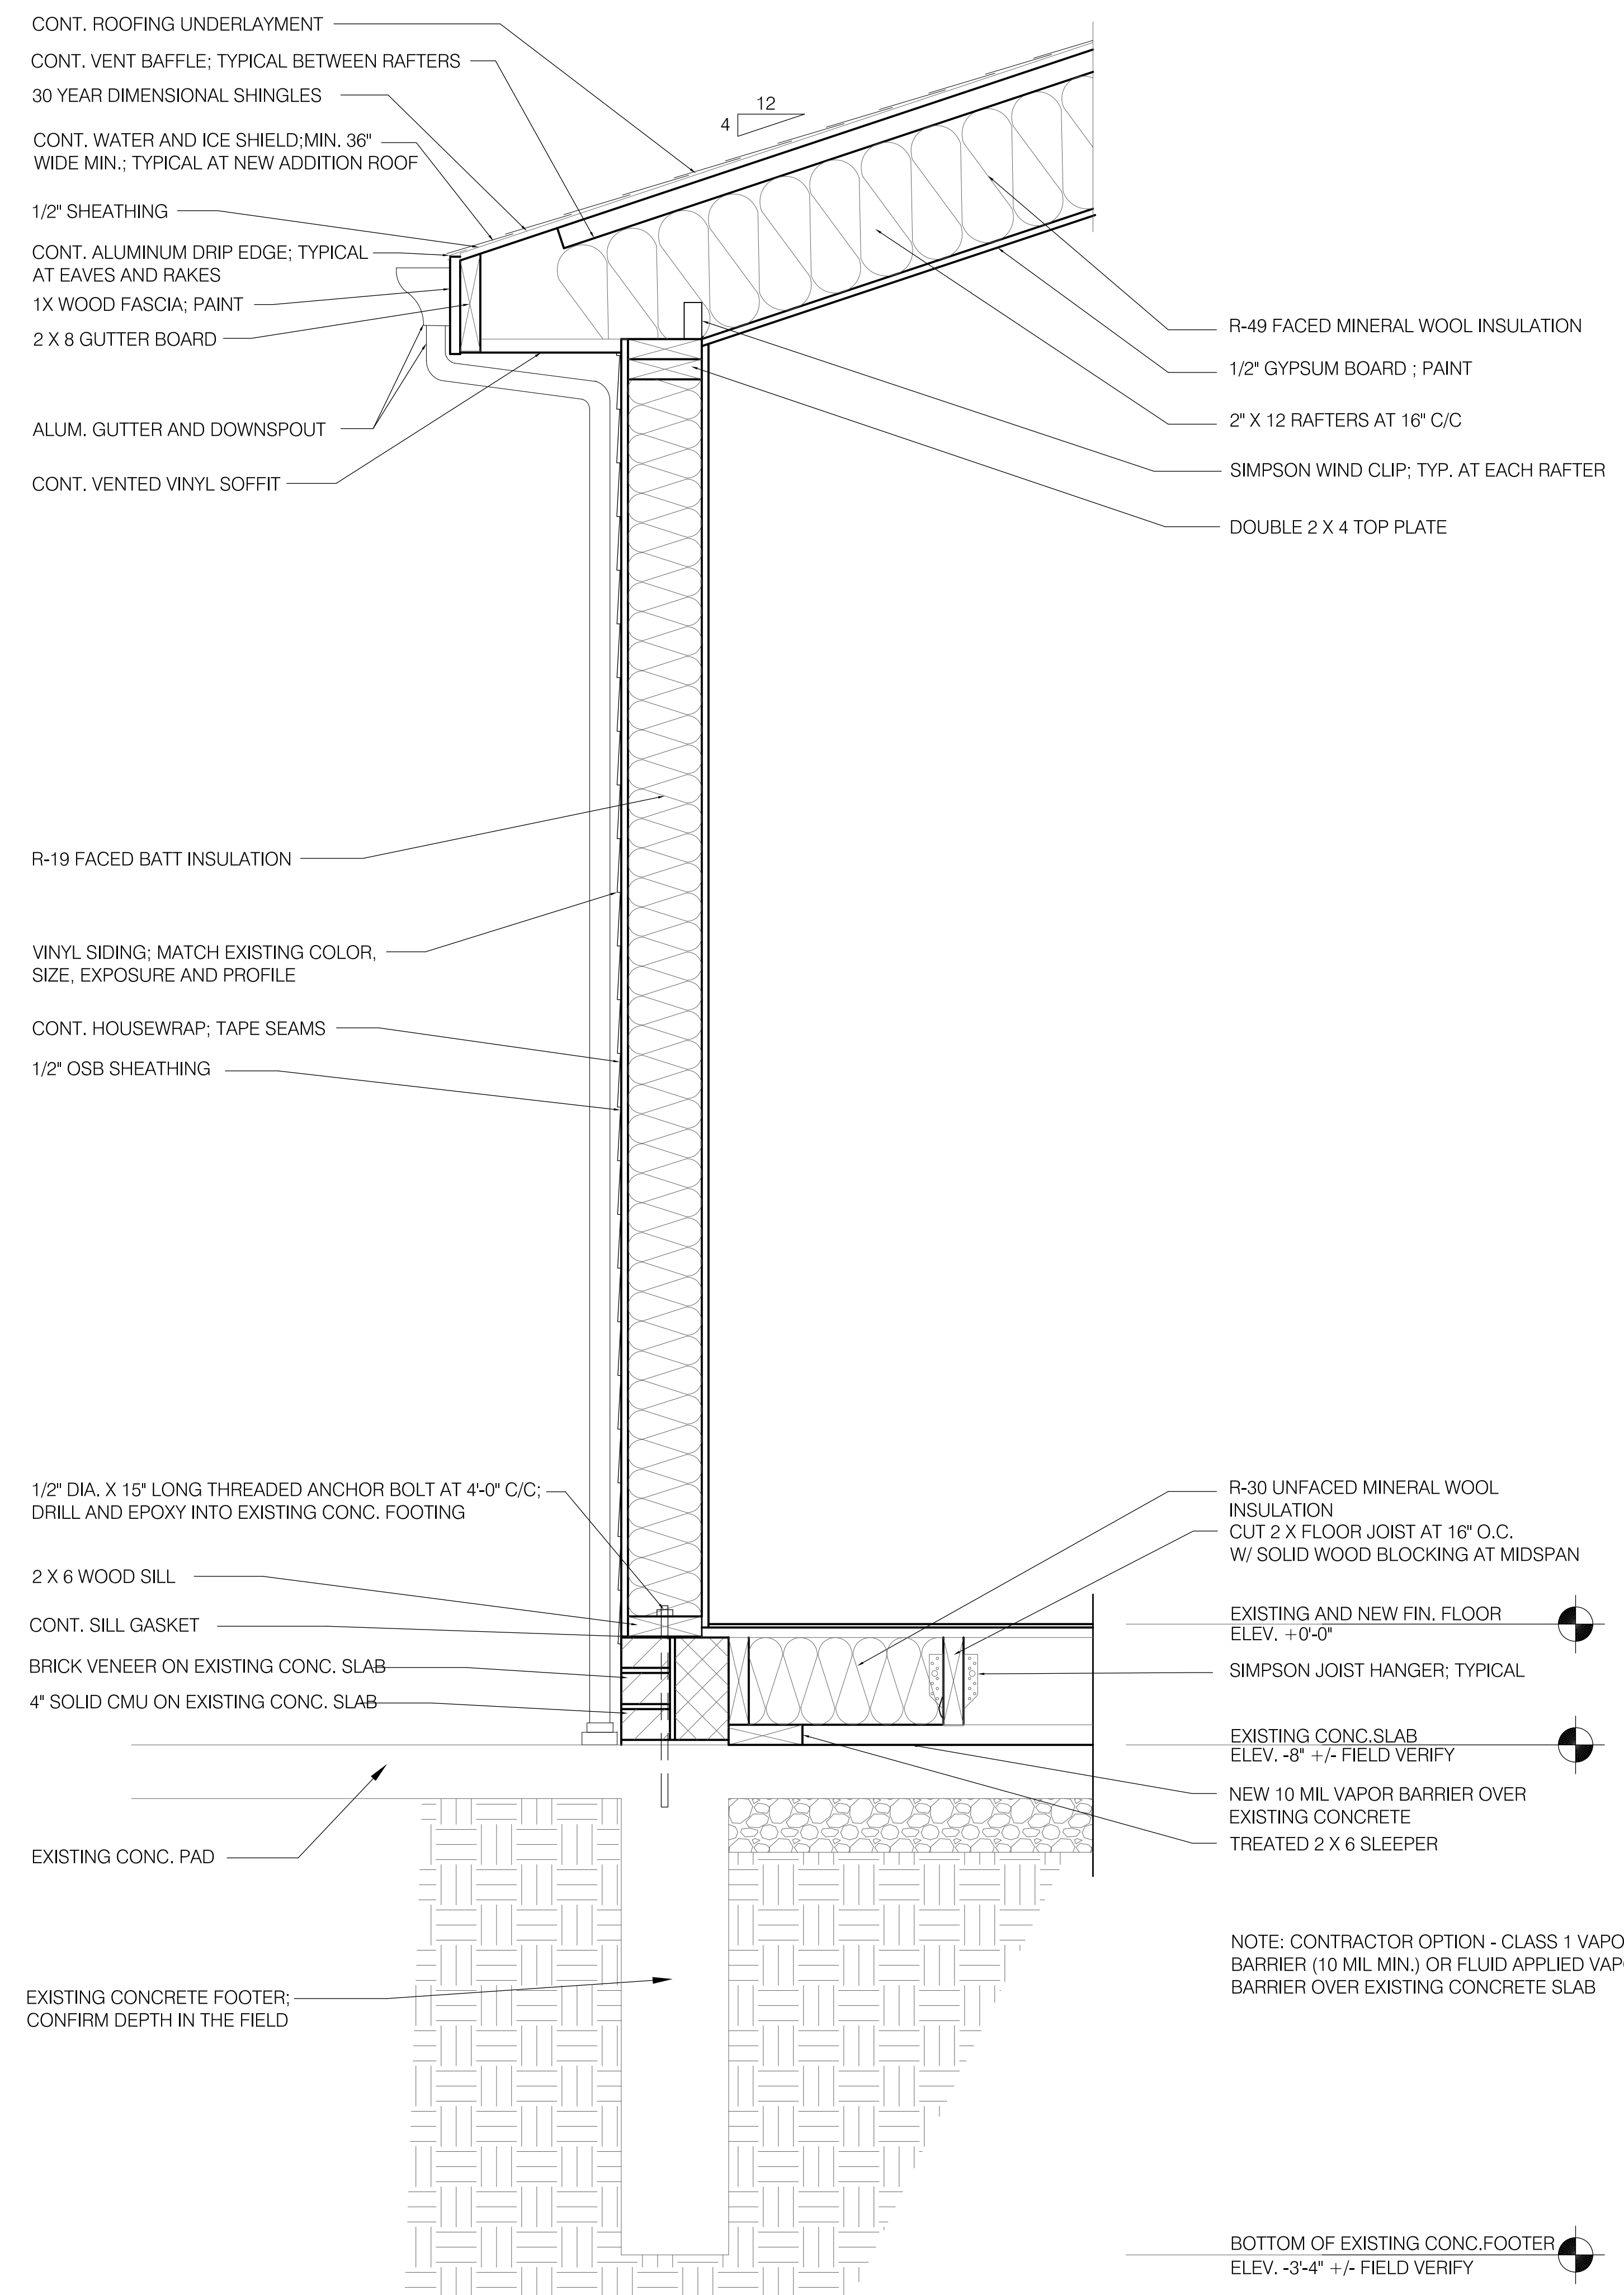

**2 WALL SECTION**  
 SCALE: 1 1/2"=1'-0"

**PROPOSED 4-SEASON PORCH FOR  
 THE BUZON RESIDENCE**  
 3130 SPENCER ROAD  
 ROCKY RIVER, OHIO 44116

**WALL SECTION  
 PROPOSED EM PLAN**

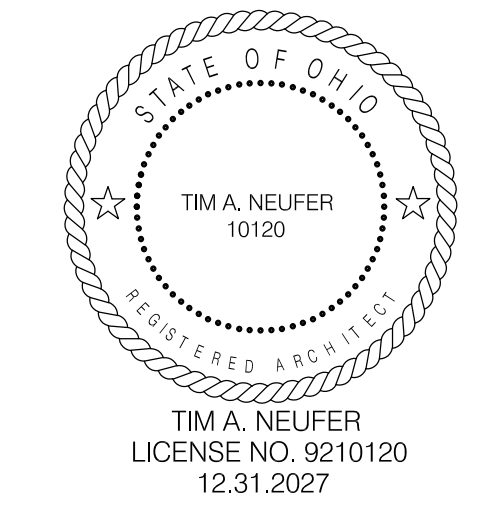

2602

A-3